


P E R S P E C T I V E

THIS SITE



S I T E D E V E L O P M E N T P L A N

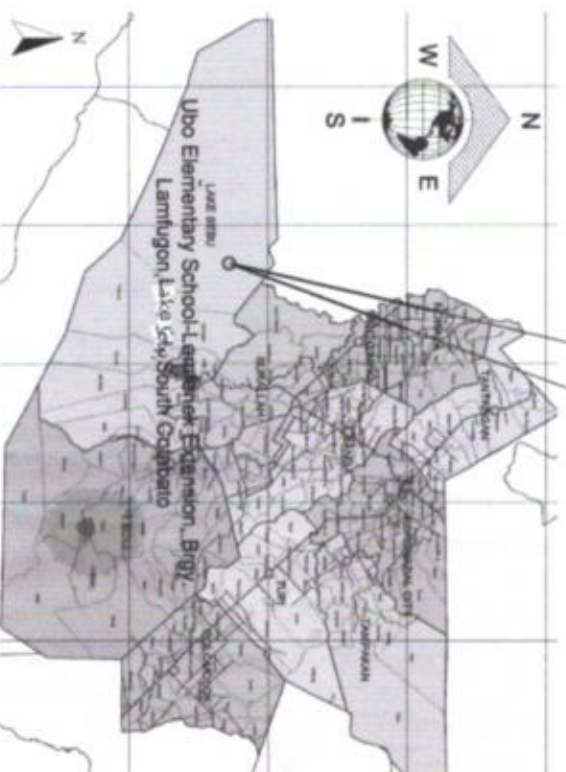


V I C I N I T Y M A P




TABLE OF CONTENTS
2 - CLASSROOM
SCHOOL BUILDING

REPUBLIC OF THE PH.
DEPARTMENT OF PUBLIC WORKS,
OFFICE OF THE BUILDING
O F F I C I A L

PLUMBING	ARCHITECTURAL	
P-1 WATER LINE LAY-OUT WATER LINE ISOMETRIC LAY-OUT	A-1 PERSPECTIVE VIEW VICINITY MAP LOCATION TABLE OF CONTENTS	LINE AND GRADE
P-2 WASTE WATER LINE LAY-OUT WASTE WATER LINE ISOMETRIC LAY-OUT	A-2 PROPOSED FLOOR PLAN	
P-3 SOLID WASTE LINE LAY-OUT SOLID WASTE LINE ISOMETRIC LAY-OUT	A-3 FRONT ELEVATION REAR SIDE ELEVATION	
P-4 SEPTIC VAULT DETAIL PEDESTAL LAVATORY DETAIL WATER CLOSET DETAIL GENERAL NOTES SPECIFICATION LEGEND	A-4 SECTION THRU "B" RIGHT SIDE ELEVATION LEFT SIDE ELEVATION	LAND USE AND ZONING
	A-5 SECTION THRU "X" BLACK BOARD DETAIL SCHEDULE OF WINDOWS	
	A-6 SCHEDULE OF DOORS DOOR SECTIONAL ELEVATION WOOD FLUSH DOOR DETAIL DOORS SPOT DETAILED - PLAN THRU "X" LOUVER BLOCKS DETAIL TYP. CEILING VENT DET.	STRUCTURAL
E-1 ELECTRICAL LIGHTING- LAY-OUT	A-7 REFLECTED CEILING PLAN CEILING DETAIL CEILING JOIST BLOW-UP- SECTIONAL ELEVATION	ARCHITECTURAL
E-2 CONVENIENCE OUTLET LAY-OUT		
E-3 CONDUIT LAY-OUT	STRUCTURAL	
E-4 ELECTRICAL RISER DIAGRAM LOAD SCHEDULE NOTES & SPECIFICATIONS LOCATION MAP	S-1 FOUNDATION PLAN	SANITARY
	S-2 CF DETAIL WALL (1) FOOTING (1) DETAIL WALL (2) FOOTING (1) DETAIL WALL (3) FOOTING (1) DETAIL RAAMP PLAN RAAMP SPOT DETAIL RAAMP AND HAND RAIL DETAIL TYPICAL BEAM DETAIL	
	S-3 ROOF FRAMING PLAN	ELECTRICAL
	S-4 ROOF FRAMING PLAN	
	S-5 THE ROD CONNECTION DET. SAG ROD CONNECTION DET. PURLINS CONNECTION DET. TYPICAL ANCHORAGE DET. DETAIL OF RAFTER SECTION DETAILS SIDE FLASHING DETAIL BLIND GUTTER DETAIL EAVES DETAIL	MECHANICAL

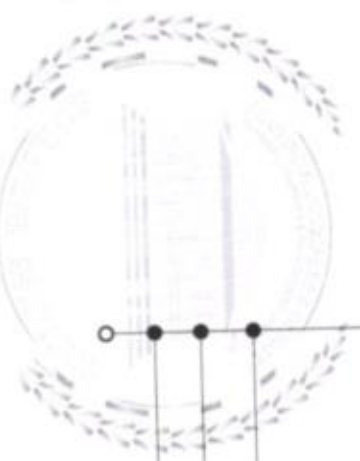


PROPOSED FLOOR PLAN
SCALE: 1:100 MTS

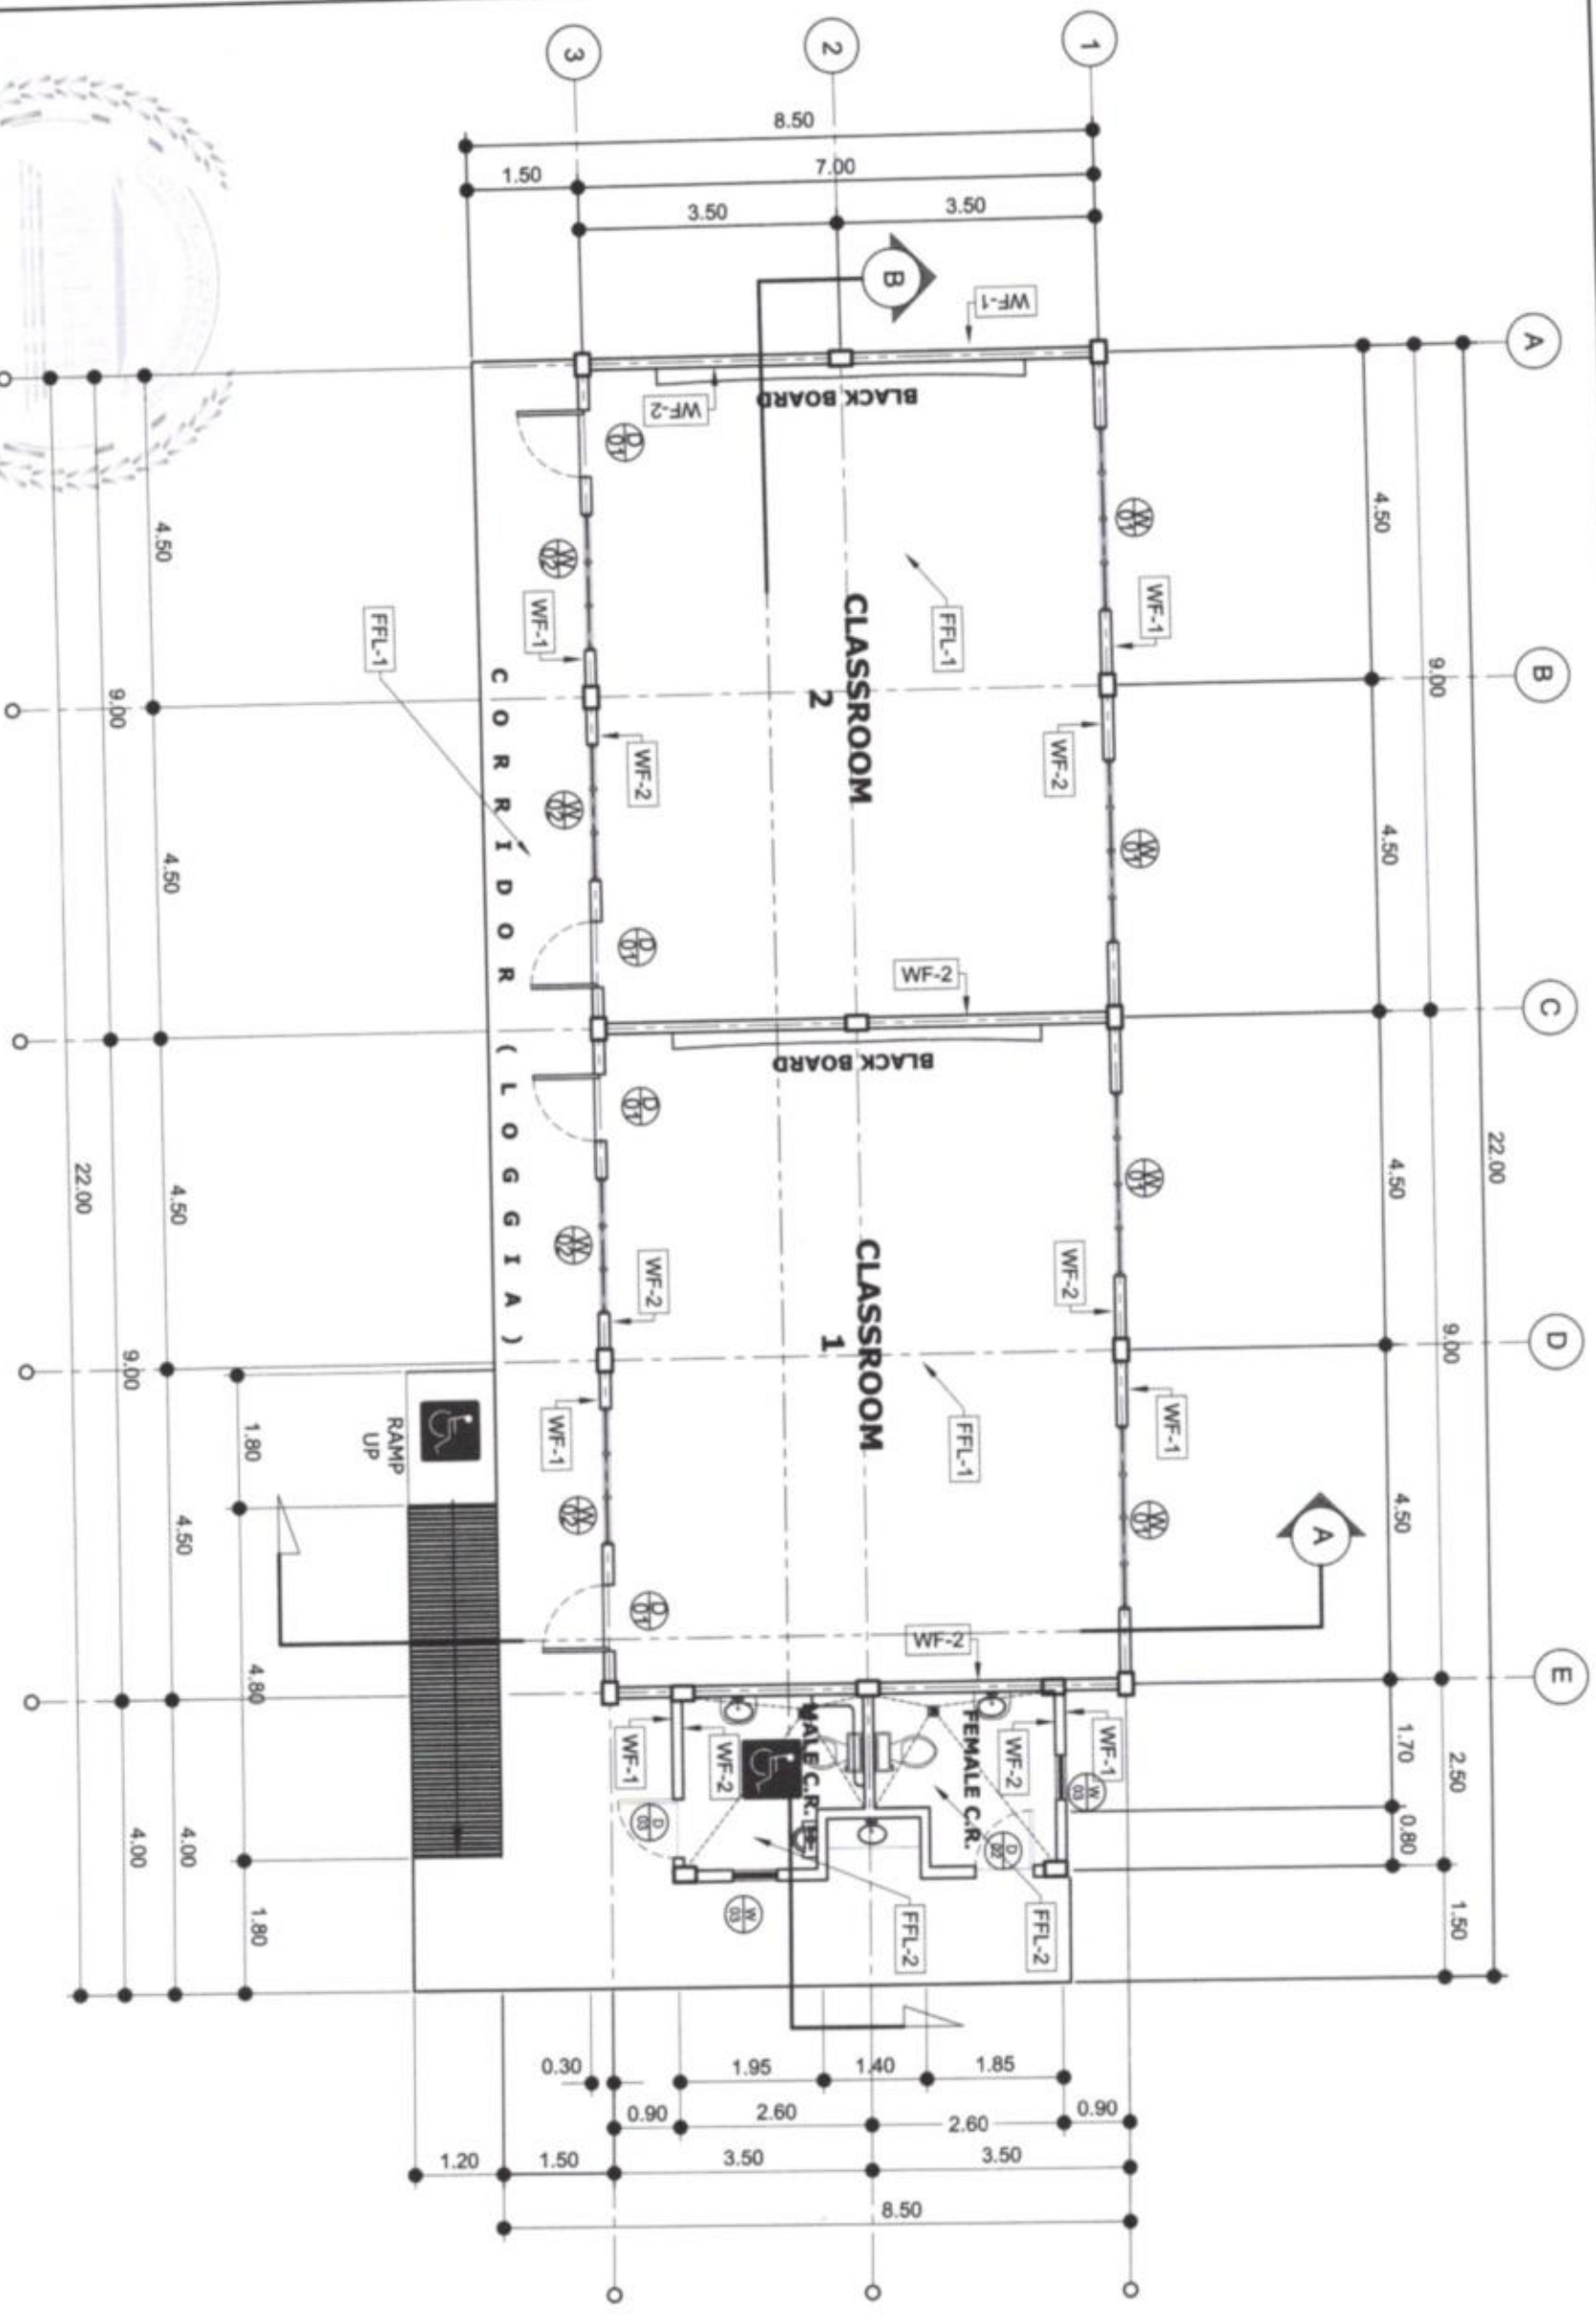


ALL ARCHITECTURAL PLANS SHALL PREVAIL OVER ALL ENGINEERING PLANS WITH REGARDS TO DIMENSIONS, ANY DISCREPANCIES FOUND HEREIN SHALL BE VERIFIED WITH THE ARCHITECT.

MARK	DESCRIPTION
WF-1	100mm thick CHB WITH FAIR FACED SMOOTH PLASTERED FINISH WITH PRIMER PAINTED FINISH WALLING COLOR : N/A
WF-2	100mm thick CHB WITH FAIR FACED SMOOTH PLASTERED FINISH WITH PRIMER PAINTED FINISH WALLING COLOR : N/A
FF-1	100mm THK. SLAB WITH FAIR FACED SMOOTH PLASTERED FINISH TILE : N/A
FF-2	100mm THK. SLAB WITH ROUGH PLASTERED FINISH TILE : 0.30m x 0.60m RUSTIC SERIES UNGLAZED CERAMIC FLOOR TILES
W1	JALOUSIE WINDOW w/ CLEAR GLASS BLADES ON SID ALUM. HOUSING ON 50 x 150mm WOOD JAMBS/FRAMES
W2	JALOUSIE WINDOW w/ CLEAR GLASS BLADES ON SID ALUM. HOUSING ON 50 x 150mm WOOD JAMBS/FRAMES
W3	JALOUSIE WINDOW w/ CLEAR GLASS BLADES ON SID ALUM. HOUSING ON 50 x 150mm WOOD JAMBS/FRAMES
D1	Wooden Panel Door w/ WOODEN AND JAMB WITH LEVER TYPE DOOR KNOB
D2	PVC DOOR w/ LOUVERED VENT AND LEVER TYPE DOOR KNOB NOTE: PROVIDE & APPLY NON-SAG EPOXY AS ADHESIVE ON DOOR HINGES PRIOR UPON SCREW FASTENING ON DOOR JAMB
D3	PVC DOOR w/ LOUVERED VENT AND LEVER TYPE DOOR KNOB NOTE: PROVIDE & APPLY NON-SAG EPOXY AS ADHESIVE ON DOOR HINGES PRIOR UPON SCREW FASTENING ON DOOR JAMB

NOTE

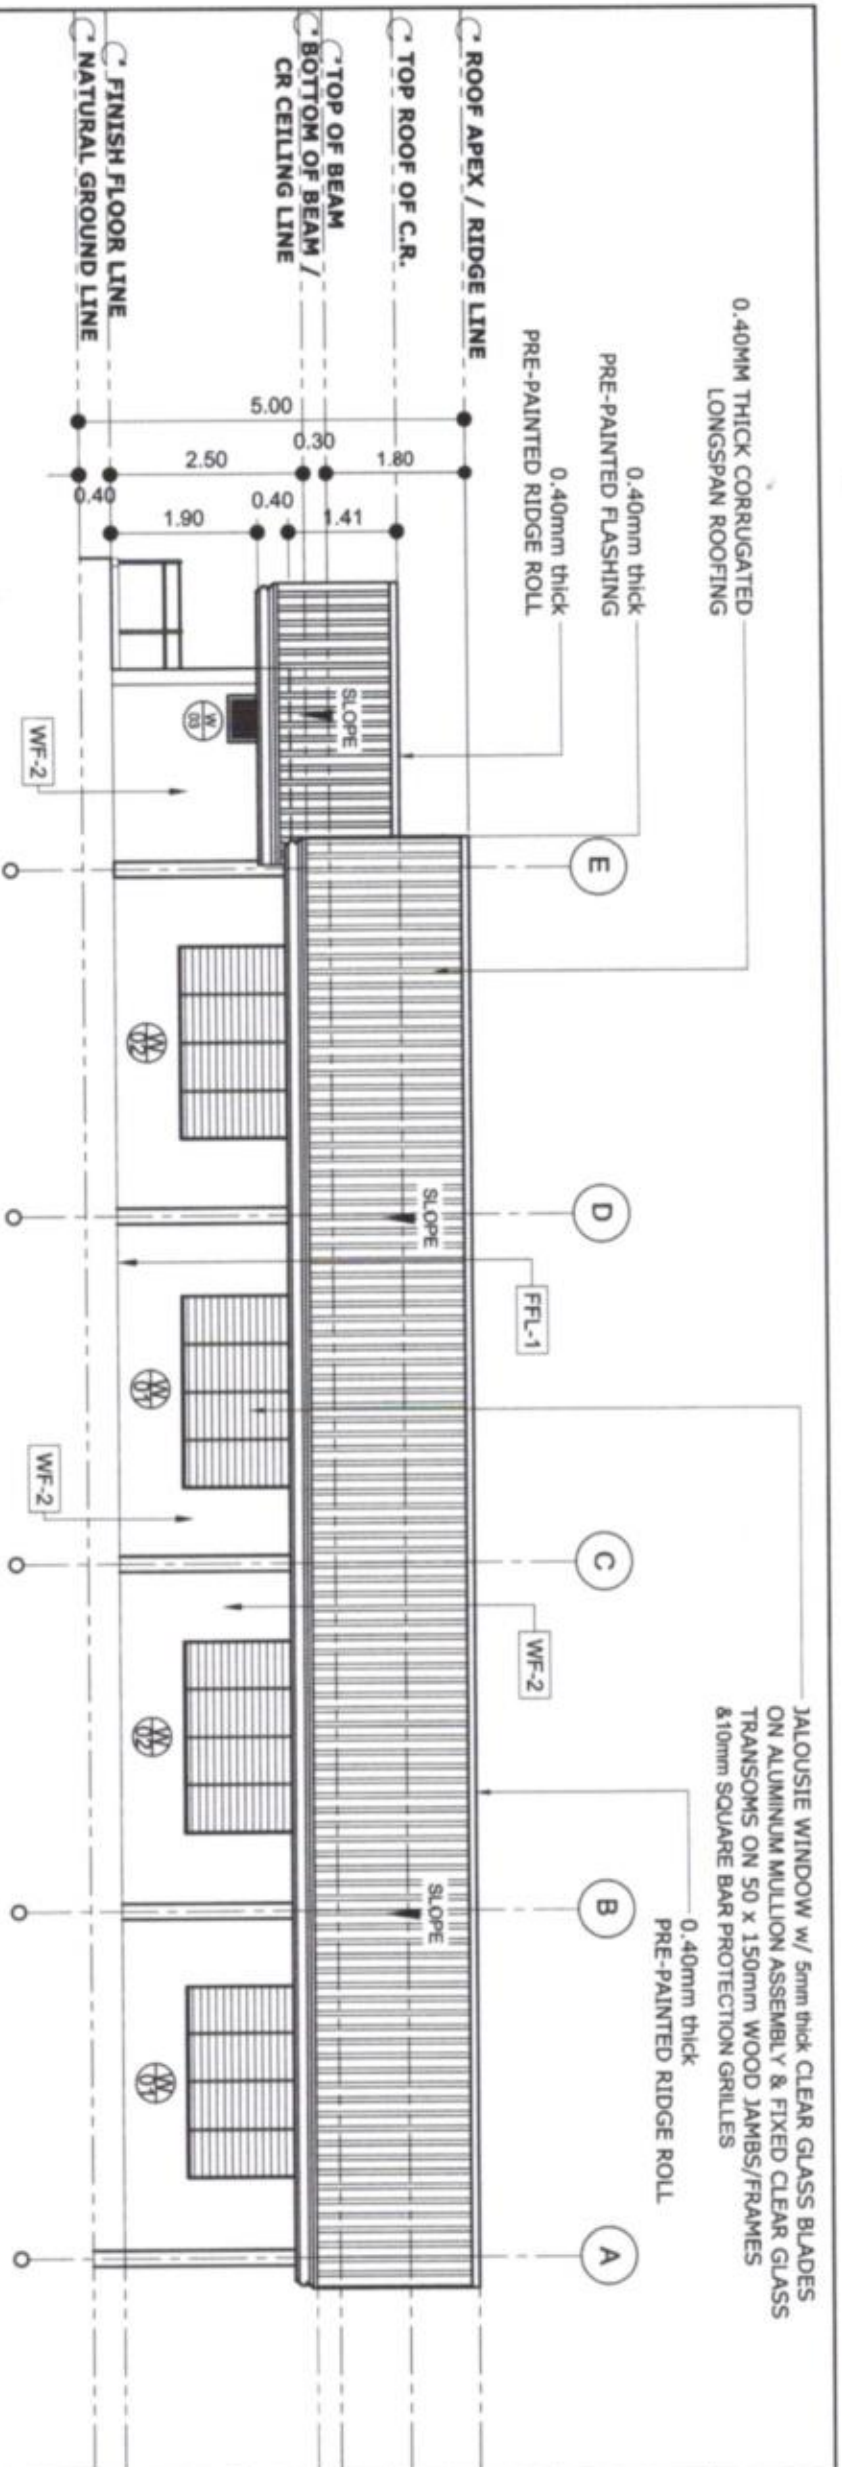


MARK	DESCRIPTION
W/F-1	100mm thick CHB WITH FAIR FACED SMOOTH PLASTERED FINISH WITH PRIMER PAINTED FINISH WALLING COLOR : N/A
W/F-2	100mm thick CHB WITH FAIR FACED SMOOTH PLASTERED FINISH WITH PRIMER PAINTED FINISH WALLING COLOR : N/A
FF-1	100mm THK. SLAB WITH FAIR FACED SMOOTH PLASTERED FINISH TILE : N/A
FF-2	100mm THK. SLAB WITH ROUGH PLASTERED FINISH TILE : 0.30m x 0.60m RUSTIC SERIES UNGLAZED CERAMIC FLOOR TILES
W1	JALOUSIE WINDOW w/ CLEAR GLASS BLADES ON SID ALUM. HOUSING ON 50 x 150mm WOOD JAMBS/FRAMES
W2	JALOUSIE WINDOW w/ CLEAR GLASS BLADES ON SID ALUM. HOUSING ON 50 x 150mm WOOD JAMBS/FRAMES
W3	JALOUSIE WINDOW w/ CLEAR GLASS BLADES ON SID ALUM. HOUSING ON 50 x 150mm WOOD JAMBS/FRAMES
D1	Wooden Panel Door w/ WOODEN AND JAMB WITH LEVER TYPE DOOR KNOB
D2	PVC DOOR w/ LOUVERED VENT AND LEVER TYPE DOOR KNOB NOTE: PROVIDE & APPLY NON-SAG EPOXY AS ADHESIVE ON DOOR HINGES PRIOR UPON SCREW FASTENING ON DOOR JAMB
D3	PVC DOOR w/ LOUVERED VENT AND LEVER TYPE DOOR KNOB NOTE: PROVIDE & APPLY NON-SAG EPOXY AS ADHESIVE ON DOOR HINGES PRIOR UPON SCREW FASTENING ON DOOR JAMB

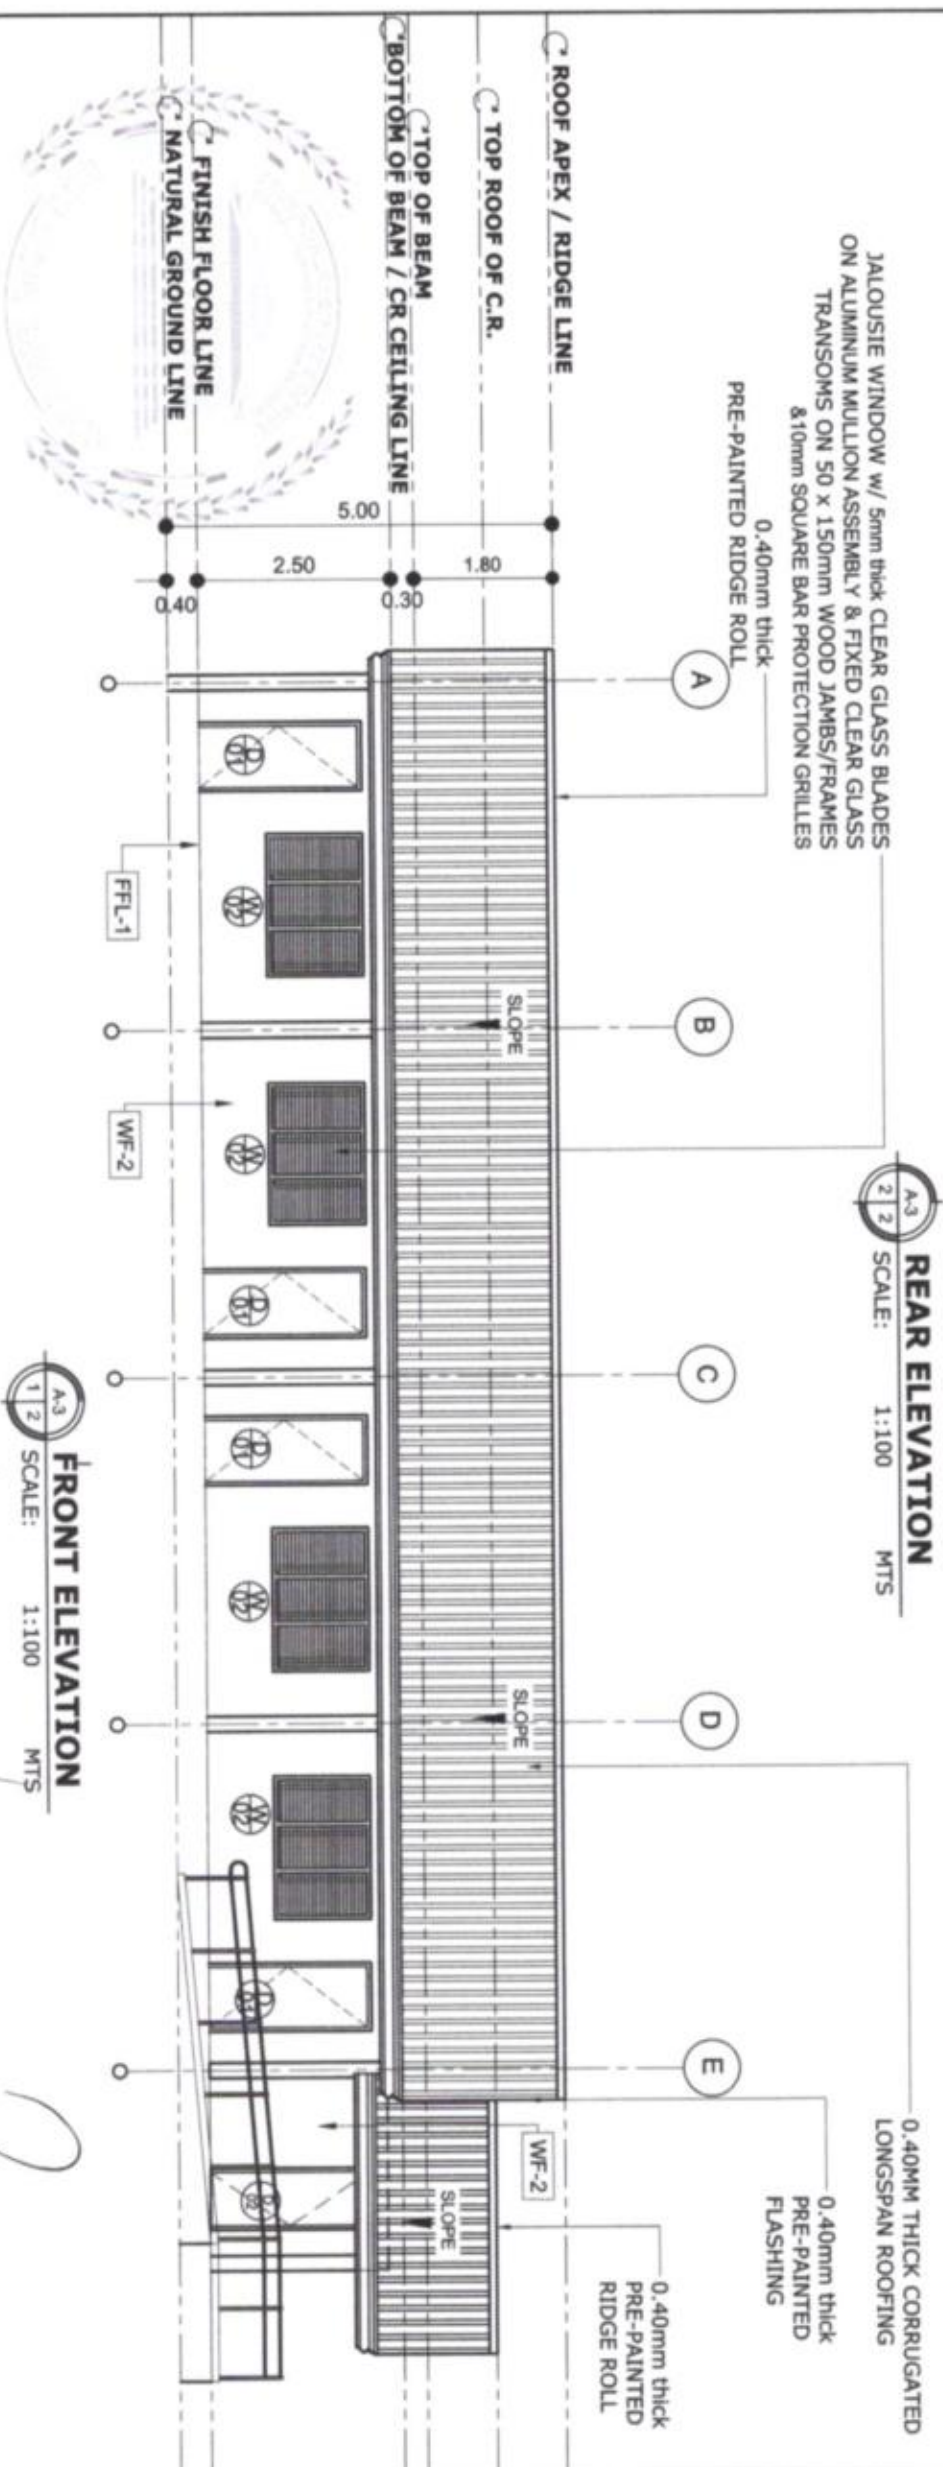


MARK	DESCRIPTION
W/F-1	100mm thick CHB WITH FAIR FACED SMOOTH PLASTERED FINISH WITH PRIMER PAINTED FINISH WALLING COLOR : N/A
W/F-2	100mm thick CHB WITH FAIR FACED SMOOTH PLASTERED FINISH WITH PRIMER PAINTED FINISH WALLING COLOR : N/A
FF-1	100mm THK. SLAB WITH FAIR FACED SMOOTH PLASTERED FINISH TILE : N/A
FF-2	100mm THK. SLAB WITH ROUGH PLASTERED FINISH TILE : 0.30m x 0.60m RUSTIC SERIES UNGLAZED CERAMIC FLOOR TILES
W1	JALOUSIE WINDOW w/ CLEAR GLASS BLADES ON SID ALUM. HOUSING ON 50 x 150mm WOOD JAMBS/FRAMES
W2	JALOUSIE WINDOW w/ CLEAR GLASS BLADES ON SID ALUM. HOUSING ON 50 x 150mm WOOD JAMBS/FRAMES
W3	JALOUSIE WINDOW w/ CLEAR GLASS BLADES ON SID ALUM. HOUSING ON 50 x 150mm WOOD JAMBS/FRAMES
D1	Wooden Panel Door w/ WOODEN AND JAMB WITH LEVER TYPE DOOR KNOB
D2	PVC DOOR w/ LOUVERED VENT AND LEVER TYPE DOOR KNOB NOTE: PROVIDE & APPLY NON-SAG EPOXY AS ADHESIVE ON DOOR HINGES PRIOR UPON SCREW FASTENING ON DOOR JAMB
D3	PVC DOOR w/ LOUVERED VENT AND LEVER TYPE DOOR KNOB NOTE: PROVIDE & APPLY NON-SAG EPOXY AS ADHESIVE ON DOOR HINGES PRIOR UPON SCREW FASTENING ON DOOR JAMB

NOTE
ALL ARCHITECTURAL PLANS SHALL PREVAIL OVER ALL ENGINEERING PLANS WITH REGARDS TO DIMENSIONS, ANY DESCRIPTANCIES FOUND HEREIN SHALL BE VERIFIED WITH THE ARCHITECT.


	PROJECT TITLE & LOCATION:	DRAFTED BY:	PREPARED BY:	CHECKED BY:	SUBMITTED BY:	RECOMMENDING APPROVAL:	APPROVED:	SHEET NO.
	CONSTRUCTION OF TWO (2) CLASSROOM BUILDING WITH ATTACHED TOILET Ubo Elementary School-Lantawan Extension, Bay-Lantawan, Lantawan, South Cotabato	JHICORIL FANLIGON, UAP ARCHITECT (U.O.)	CARL FRANCIS I. GARCIA, UAP ARCHITECT II	GLENDALE B. MARFIL, UAP ARCHITECT II - VERTICAL SECTION HEAD	FREDERICK S. SORIANO, MPA HEAD, Planning, Programming & Designing Division	MARITO S. PEREROCHO, MPA PROVINCIAL ENGINEER	REYNALDO S. TAMAYO, JR. PROVINCIAL GOVERNOR	A 3 3/22

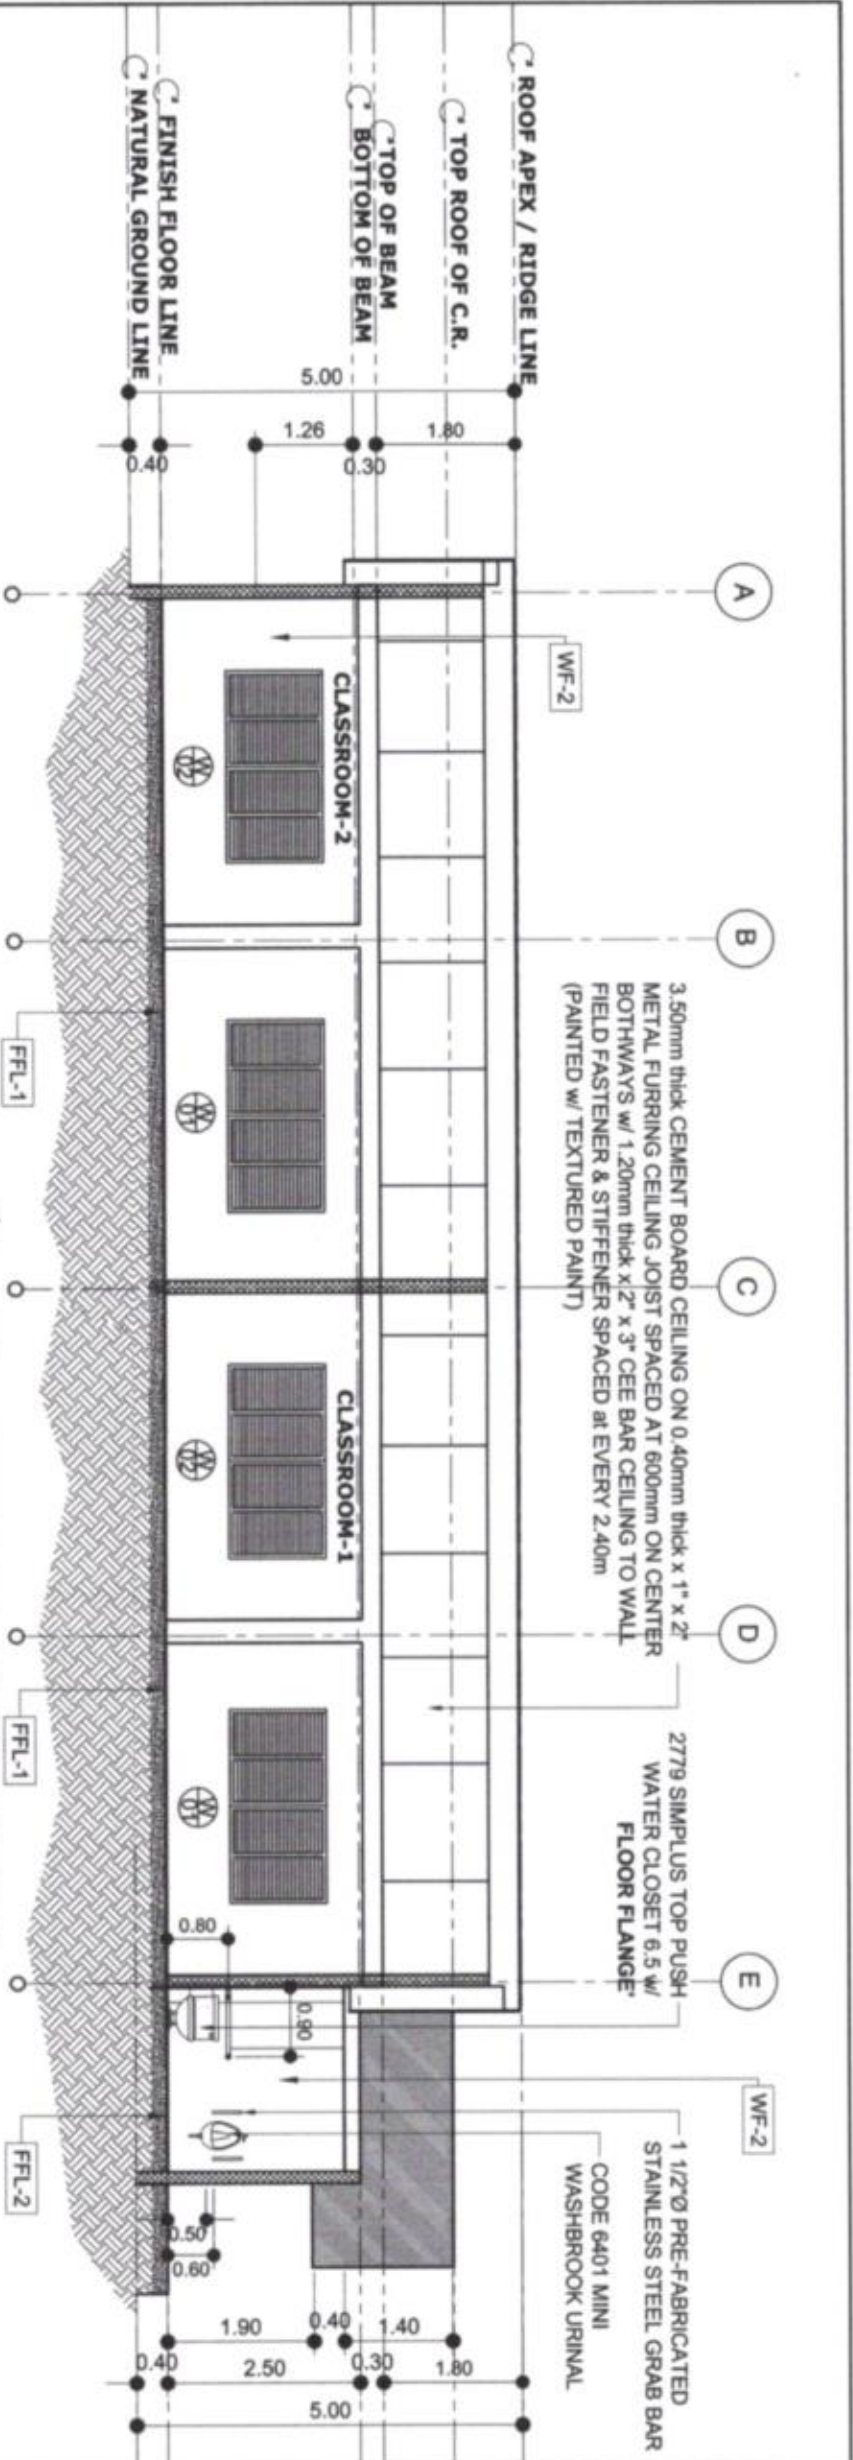

LONGITUDINAL SECTIONAL THRU 'B'
SCALE: 1:100 MTS

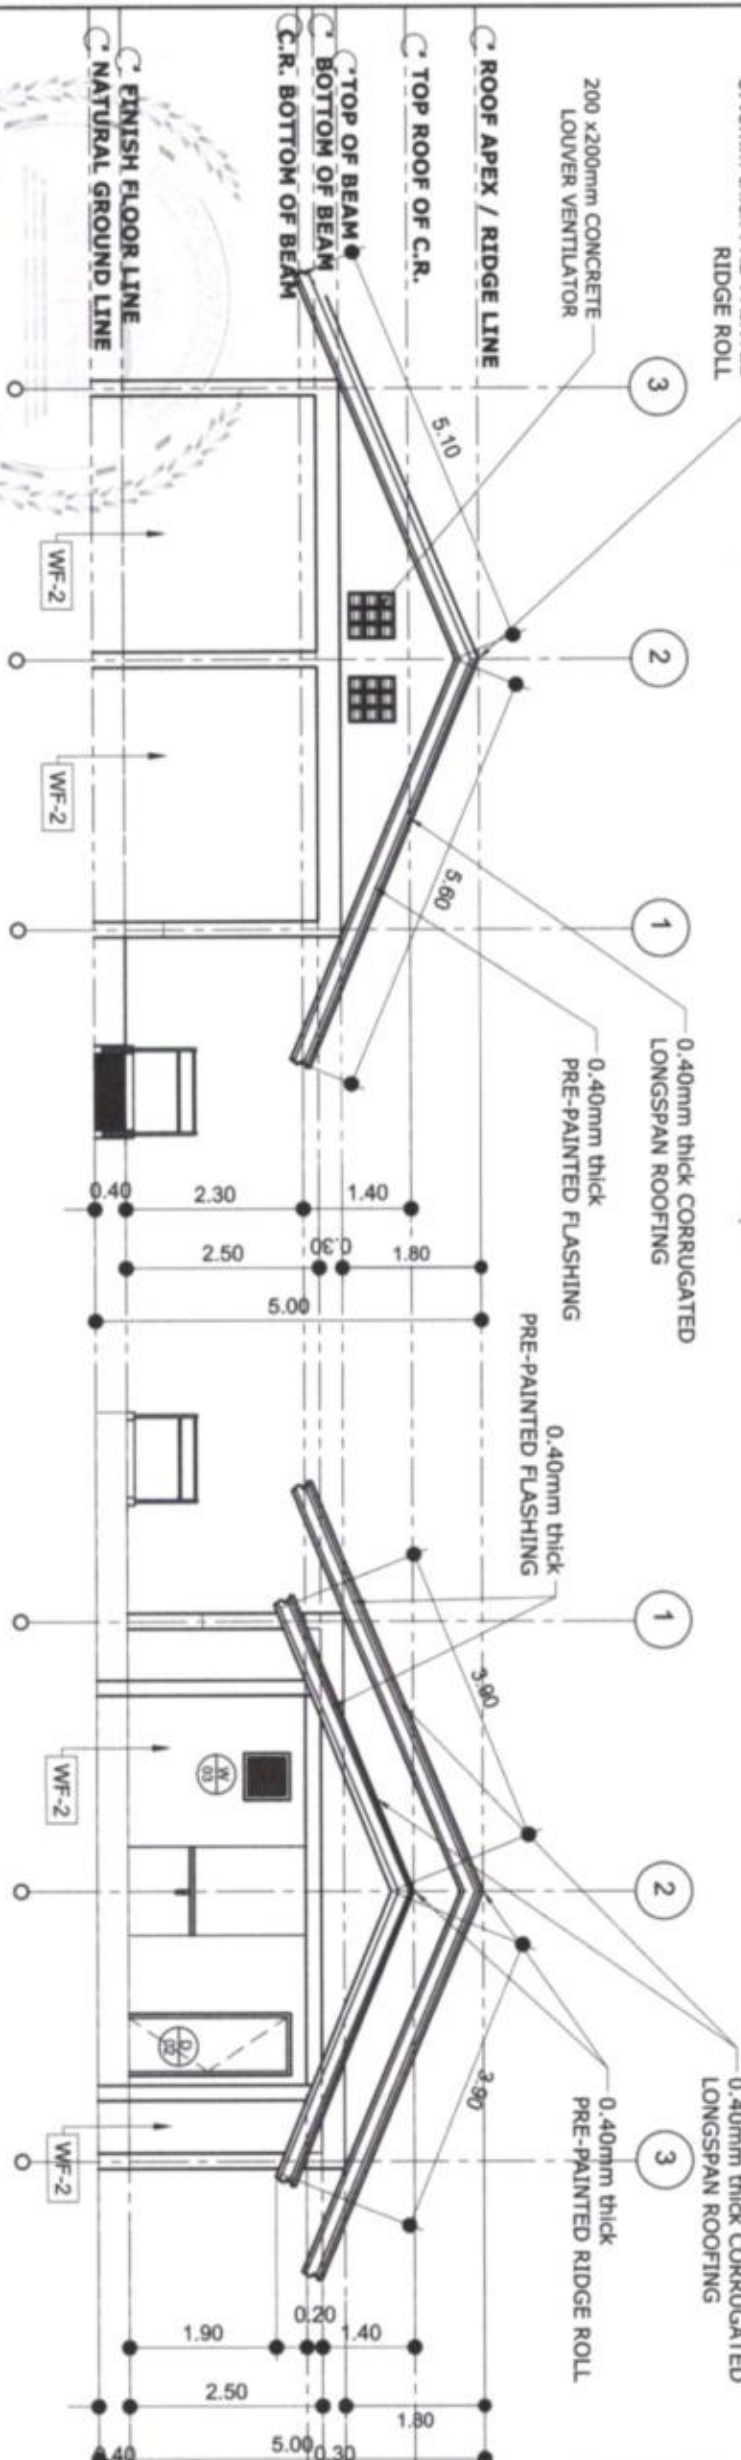

LEFT-SIDE ELEVATION
SCALE: 1:100 MTS

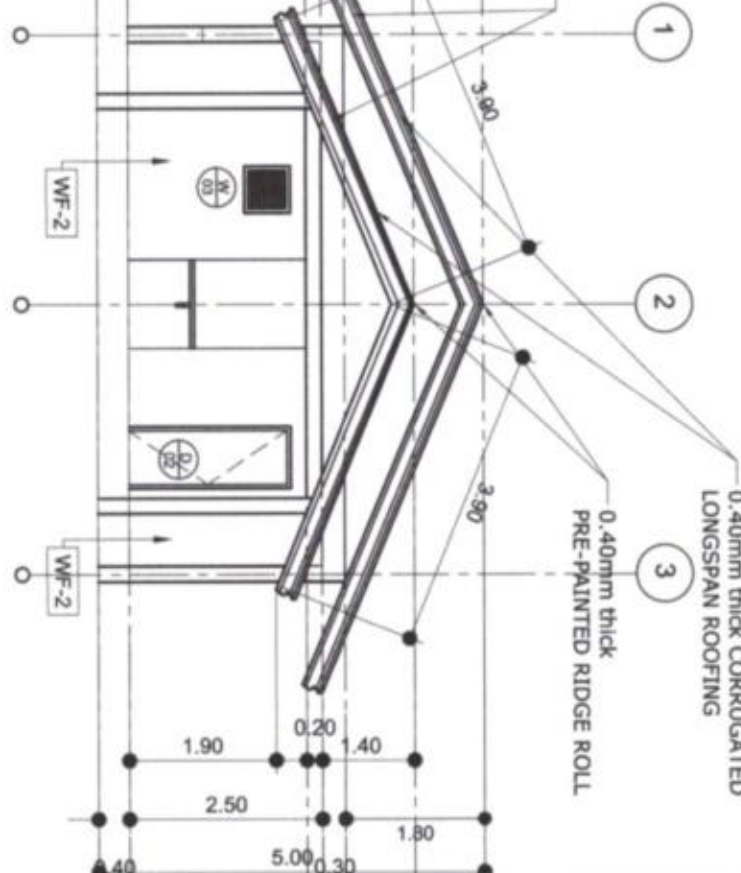


RIGHT-SIDE ELEVATION
SCALE: 1:100 MTS

MARK	DESCRIPTION
WF-1	100mm thick CHB WITH FAIR FACED SMOOTH PLASTERED FINISH WITH PRIMER PAINTED FINISH WALLING COLOR : N/A
WF-2	100mm thick CHB WITH FAIR FACED SMOOTH PLASTERED FINISH WITH PRIMER PAINTED FINISH WALLING COLOR : N/A
FF-1	100mm THK. SLAB WITH FAIR FACED SMOOTH PLASTERED FINISH TITLE : N/A
FF-2	100mm THK. SLAB WITH ROUGH PLASTERED FINISH TITLE : 0.30m x 0.60m RUSTIC SERIES UNGLAZED CERAMIC FLOOR TILES
W1	JALOUSIE WINDOW w/ CLEAR GLASS BLADES ON SID ALUM. HOUSING ON 50 x 150mm WOOD JAMBS/FRAMES
W2	JALOUSIE WINDOW w/ CLEAR GLASS BLADES ON SID ALUM. HOUSING ON 50 x 150mm WOOD JAMBS/FRAMES
W3	JALOUSIE WINDOW w/ CLEAR GLASS BLADES ON SID ALUM. HOUSING ON 50 x 150mm WOOD JAMBS/FRAMES
D1	Wooden Panel Door w/ WOODEN AND JAMB WITH LEVER TYPE DOOR KNOB
D2	PVC DOOR w/ LOUVERED VENT AND LEVER TYPE DOOR KNOB NOTE: PROVIDE A APPLY NON-SAG EPOXY AS ADHESIVE ON DOOR HINGES PRIOR UPON SCREW FASTENING ON DOOR JAMB
D3	PVC DOOR w/ LOUVERED VENT AND LEVER TYPE DOOR KNOB NOTE: PROVIDE A APPLY NON-SAG EPOXY AS ADHESIVE ON DOOR HINGES PRIOR UPON SCREW FASTENING ON DOOR JAMB
NOTE	
ALL ARCHITECTURAL PLANS SHALL PREVAIL OVER ALL ENGINEERING PLANS WITH REGARDS TO DIMENSIONS, ANY DESCRIPTANCES FOUND HEREIN SHALL BE VERIFIED WITH THE ARCHITECT.	


REPUBLIC OF THE PHILIPPINES PROVINCE OF SOUTH COTABATO OFFICE OF THE PROVINCIAL ENGINEER PLANNING, PROGRAMMING & DESIGNING DIVISION KORONADAL CITY		PROJECT TITLE & LOCATION: CONSTRUCTION OF TWO (2) CLASSROOM BUILDING WITH ATTACHED TOILET Libo Elementary School-Lambanak Extension, Brgy. Lambanak, Lingsa, South Cotabato		DRAFTED BY: JHICOR L. FANUGON, UAP ARCHITECT (U.O.)	PREPARED BY: CARL FRANCIS I. GARCIA, UAP ARCHITECT II	CHECKED BY: GLENDALE B. MARFIL, UAP ARCHITECT III - VERTICAL SECTION HEAD	SUBMITTED BY: FREDERICK D. SORIANO, MPA HEAD, Planning, Prog & Designing Division	RECOMMENDING APPROVAL: MARNILLO S. AYERBACHO, MPA PROVINCIAL ENGINEER	APPROVER: REYNALDO S. TAMAYO, JR. PROVINCIAL GOVERNOR	SHEET NO: A 4 4 22
--	--	---	--	---	---	---	---	---	---	--------------------------



APPROVED:	SHEET NO.				
REYNALDO S. TAMAYO, JR. PROVINCIAL GOVERNOR	<table border="1"> <tr> <td>A</td> <td>5</td> </tr> <tr> <td>5</td> <td>22</td> </tr> </table>	A	5	5	22
A	5				
5	22				

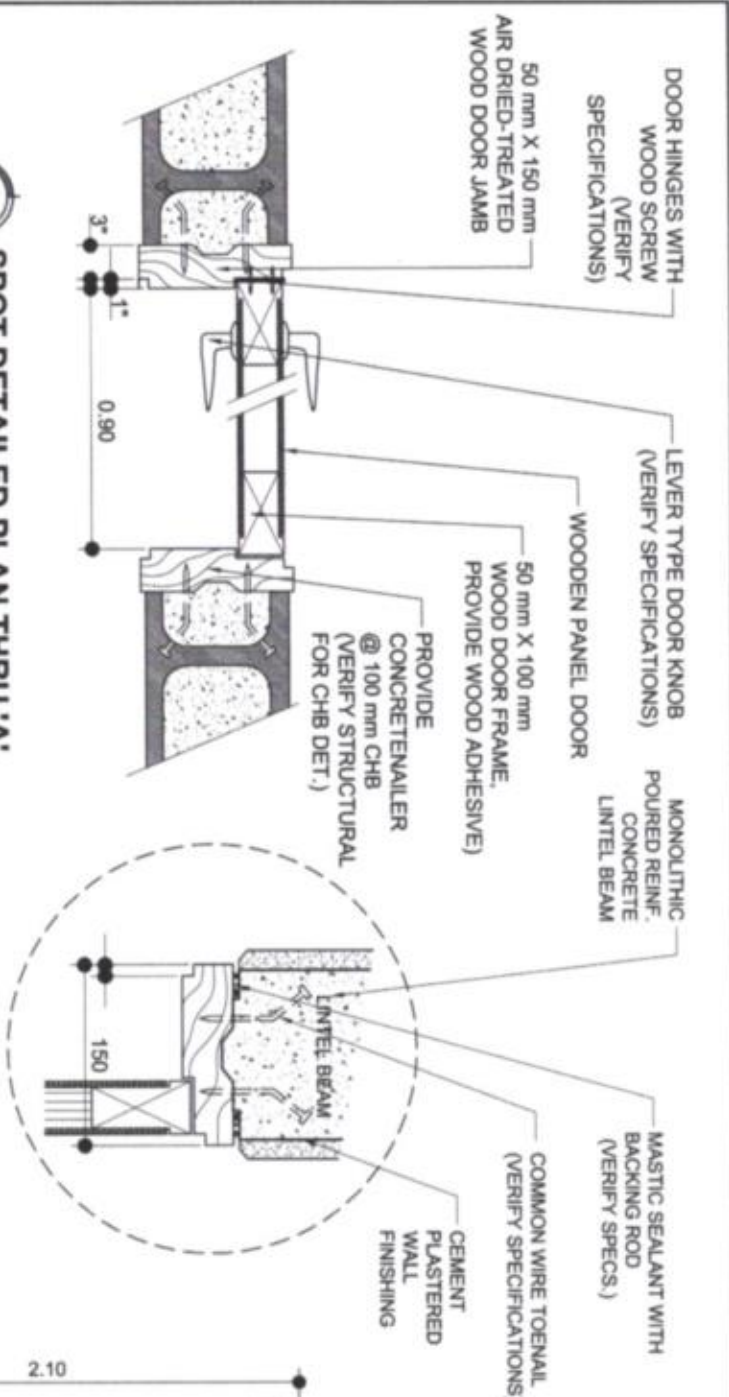


SPOT DETAILED PLAN THRU 'A'
SCALE: 1:50 MTS.

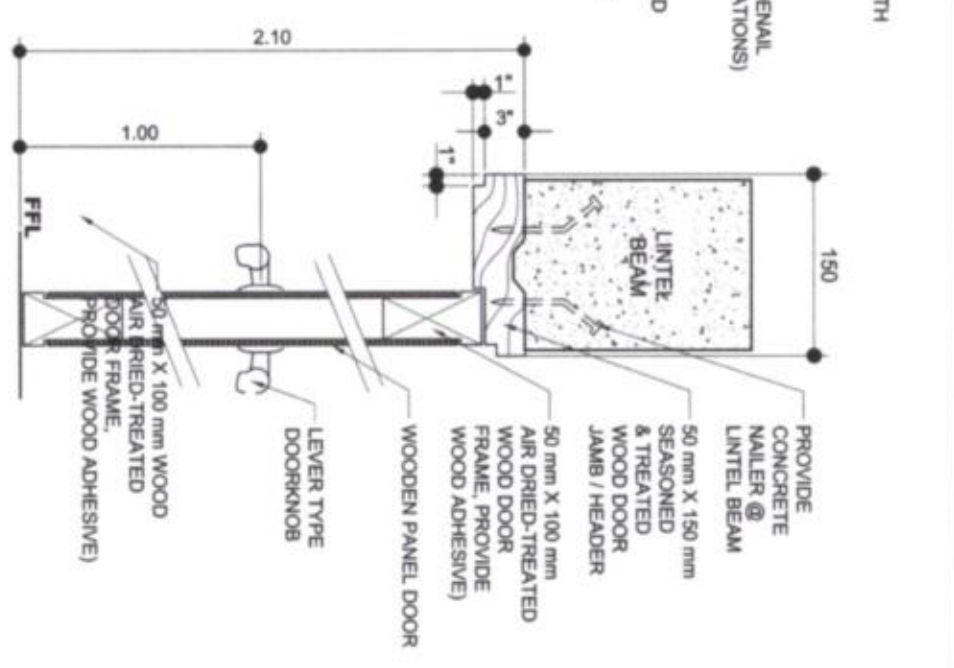


SPOT DETAIL SECTION THRU 'B'
SCALE: 1:50 MTS.

DESCRIPTION:	LOCATION:	UNIT:
D1: MONOLITHIC POURED REINF. CONCRETE LINTEL BEAM	CLASSROOM	4
D2: MONOLITHIC POURED REINF. CONCRETE LINTEL BEAM	Comfort Rooms	1
D3: MONOLITHIC POURED REINF. CONCRETE LINTEL BEAM	Comfort Rooms/ PWD	1


SCHEDULE OF DOORS
SCALE: 1:50 MTS.

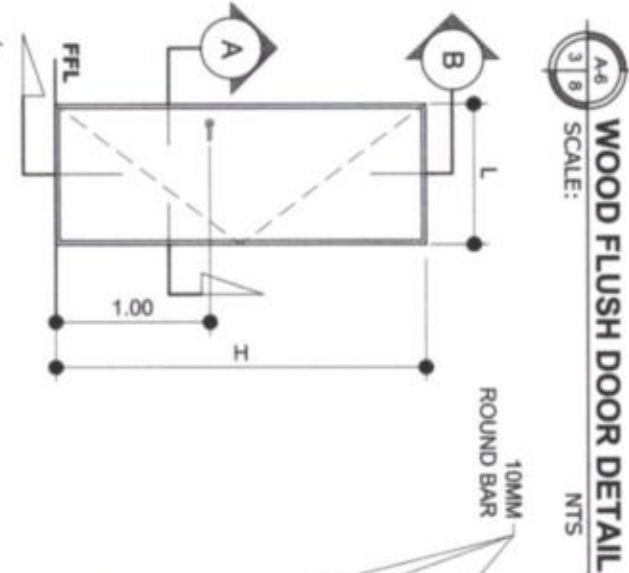


WOOD FLUSH DOOR DETAIL
SCALE: 1:50 MTS.

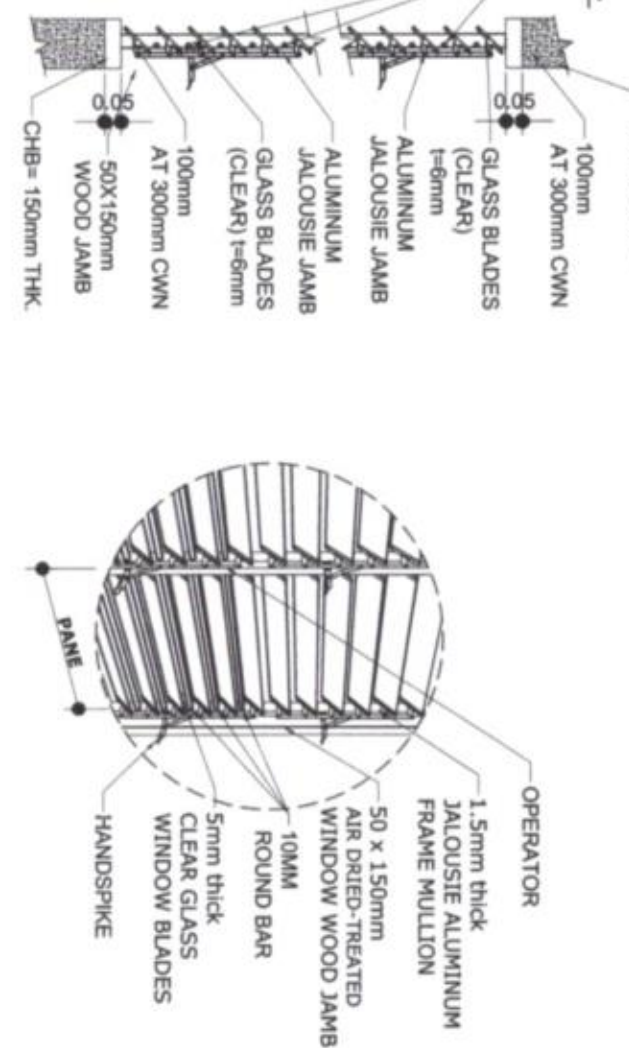


JALOUSIE SHOP DRAWING
SCALE: 1:50 MTS.

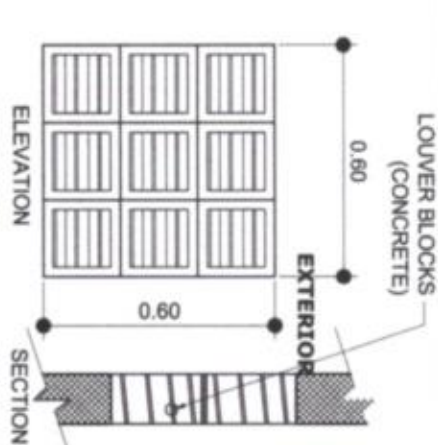

LOUVER BLOCKS DETAIL
SCALE: 1:20 MTS.

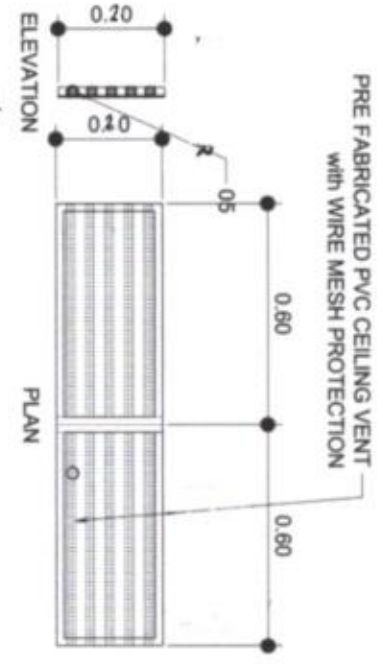

TYP. CEILING VENT DET.
SCALE: 1:20 MTS.

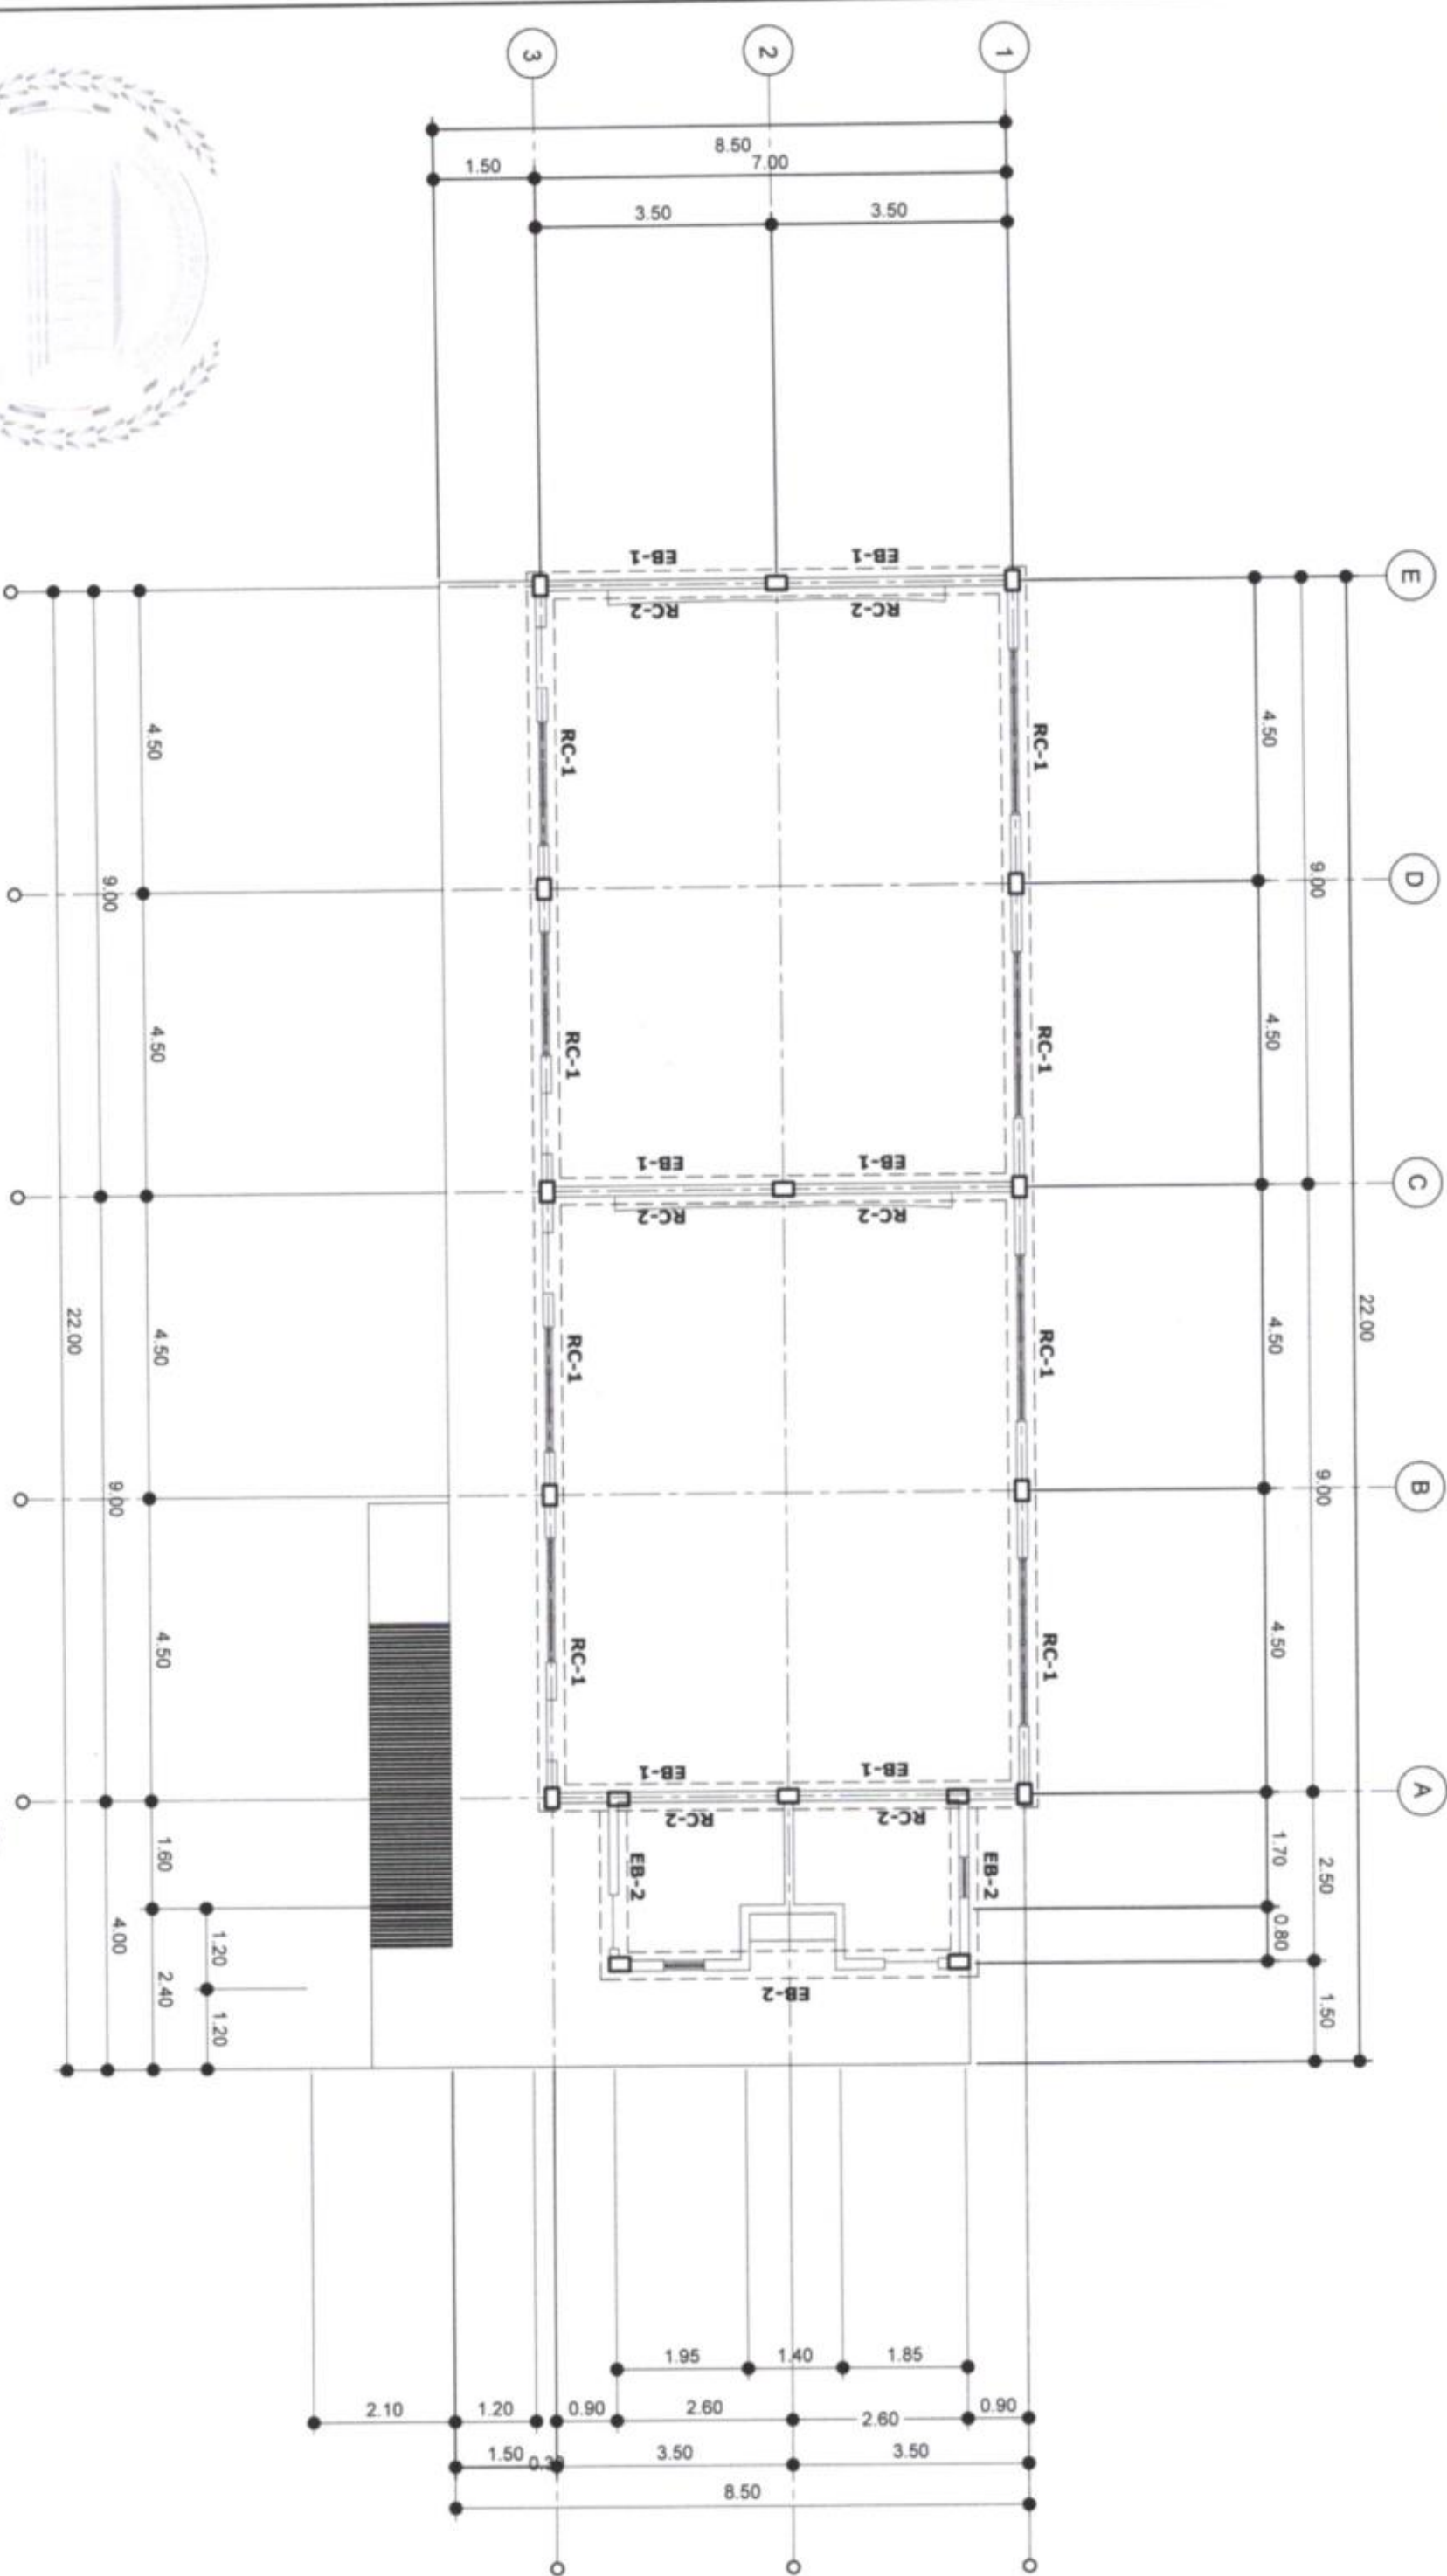

BEAM PLAN
SCALE: 1:100 MTS.



REPUBLIC OF THE PHILIPPINES
PROVINCE OF SOUTH COTABATO
OFFICE OF THE PROVINCIAL ENGINEER
PLANNING, PROGRAMMING & DESIGNING DIVISION
KORONADAL CITY

PROJECT TITLE & LOCATION:
CONSTRUCTION OF TWO (2) CLASSROOM
BUILDING WITH ATTACHED TOILET
Udo Elementary School, Lantawan Extension,
Brgy. Lantawan, Lantawan, South Cotabato

DRAFTED BY:
JHICOR L. FANUGON, UAP
APC PROJECT (U.O.)

PREPARED BY:
KRISTIANNA S. SERVAÑEZ
ENGINEER

CHECKED BY:
GLENDALE B. MARFIL, UAP
ARCHITECT II, VERTICAL SECTION HEAD

SUBMITTED BY:
FREDERICK D. SORIANO, MPA
HEAD, Planning, Program & Designing Division


RECOMMENDING APPROVAL:
MARNIL Q. S. APEROCHO, MPA
PROVINCIAL ENGINEER

APPROVED:
REYNALDO S. TAMAYO, JR.
PROVINCIAL GOVERNOR

SHEET NO.
S 1
9 22

SCHEDULE OF FOOTING

FOOTING MARK	FOOTING DIMENSIONS (mm)			REINFORCEMENTS	
	LENGTH (L)	WIDTH (W)	DEPTH (D)	THICKNESS (t)	
F - 1	800	800	1200	250	4 - 16mm $\varnothing$
F - 2	1000	1000	1200	250	4 - 16mm $\varnothing$
F - 3	900	900	1200	250	4 - 16mm $\varnothing$
F - 4	800	800	800	250	4 - 16mm $\varnothing$

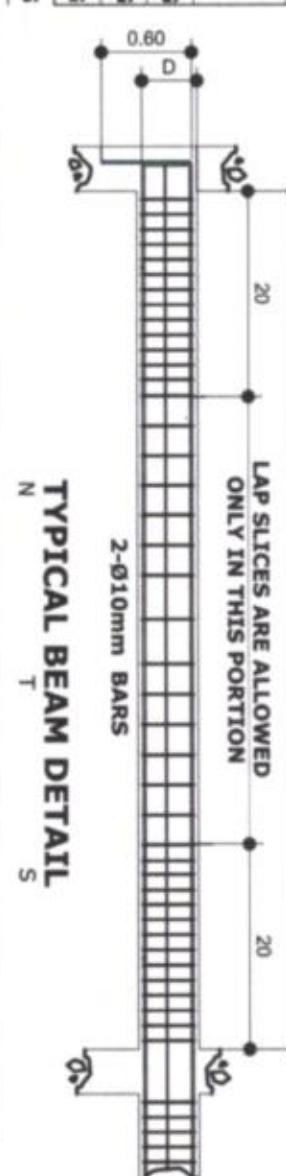


DESIGN CRITERIA	
A. CONCRETE	$f'_c = 20,685 \text{ Mpa}$ (3,000 Psi), minimum compressive strength of concrete a 28 days unless otherwise specified.
B. REBAR	$f_y = 230 \text{ Mpa}$ (33,000 Psi), minimum yield strength of reinforcing bars unless otherwise specified
C. STRUCTURAL	$F_y = 248 \text{ Mpa}$ (36 Ksi), specified minimum yield strength unless otherwise specified
D. FOUNDATION	$SBP = 95,706 \text{ Kpa}$ (2,000 Psi), w as used in the design for all footings.

No footing shall rest on fill.

COLUMN SCHEDULE	
LEVEL	C - 1
FOUNDATION LEVEL TO ROOF LEVEL	0.20 0.30 MAIN BAR: 4 - $\varnothing$ 16mm TIES: $\varnothing$ 10mm 1$\varnothing$50, 8$\varnothing$75, REST @ 150mm TO CENTER
	C - 2
	0.20 0.30 MAIN BAR: 6 - $\varnothing$ 16mm TIES: $\varnothing$ 10mm 1$\varnothing$50, 8$\varnothing$75, REST @ 150mm TO CENTER

B E A M S C H E D U L E													
FLOOR LEVEL	BEAM MARK	BEAM DIMENSIONS (in / mm)		REBAR (mm Ø)	STEEL REINFORCEMENTS								STIRRUPS Ø 10mm (UNLESS NOTED OTHERWISE)
		b	h		LEFT		MID SPAN		RIGHT				
					TOP	BOTTOM	TOP	BOTTOM	TOP	BOTTOM			
ROOF LEVEL	RC-1	150	400	Ø 16mm	2	2	2	2	2	2		1@50, 8@100, REST @200	
	RC-2	150	400	Ø 16mm	2	2	2	2	2	2		1@50, 8@100, REST @200	
	EB-1	150	250	Ø 10mm	2	2	2	2	2	2		1@50, REST @200	
	EB-2	150	200	Ø 10mm	2	2	2	2	2	2		1@50, REST @200	

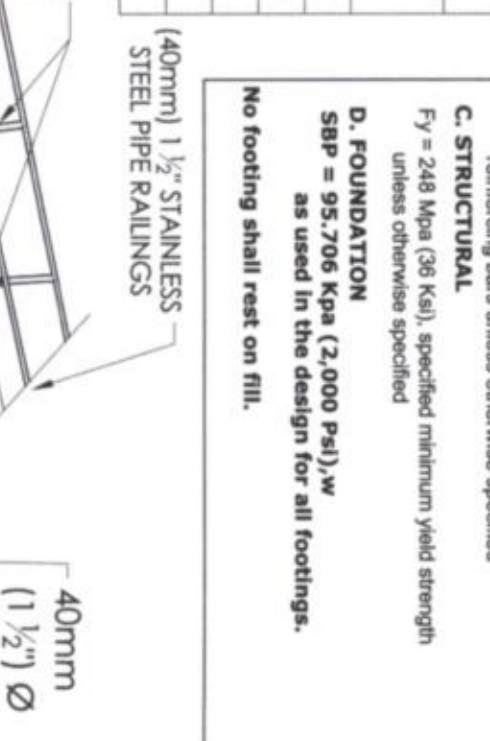





4 - 16mm $\varnothing$ MAIN BARS / 6 - 16mm $\varnothing$ MAIN BARS

10mm $\varnothing$ LATERAL TIES SPACED @ 5-0.05M, 5-0.10M & REST @ 0.20M O.C.

12mm ($\frac{1}{2}$ ") WIDE GROOVE SPACED AT 0.10M ON CENTER

40mm ($1\frac{1}{2}$ ") STAINLESS STEEL PIPE RAILINGS

40mm ($1\frac{1}{2}$ ") $\varnothing$ STAINLESS STEEL END CAP

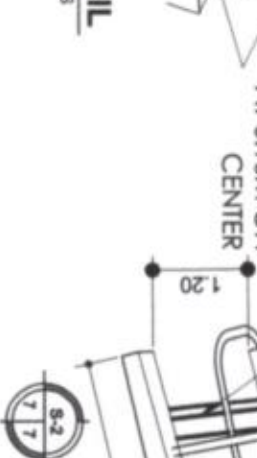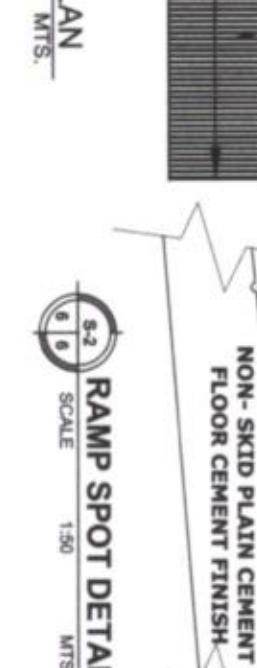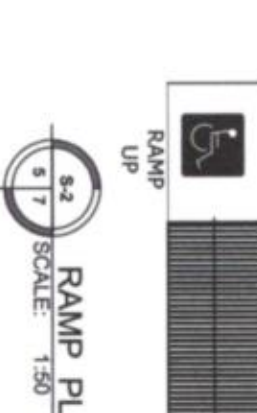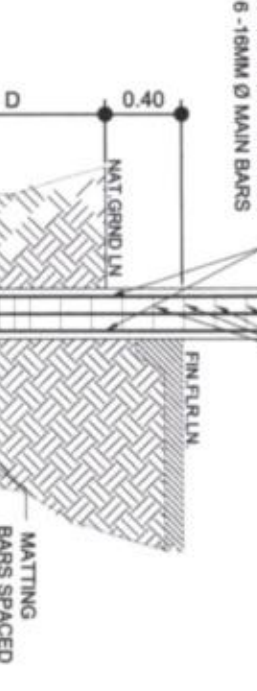

10mm $\varnothing$ TRAVERSE BARS SPACED EVERY 0.40m

10mm DIA. VERTICAL BARS SPACED @ 0.60M

10mm DIA. HOR BARS @ EVERY 3 LAYERS OF CHB

10mm DIA. VERTICAL BARS SPACED @ 0.60M

10mm $\varnothing$ TRAVERSE BARS SPACED EVERY 0.40m

3 - 10mm $\varnothing$ MAIN BARS

4" CHB

10mm DIA. HOR BARS @ EVERY 3 LAYERS OF CHB

10mm DIA. VERTICAL BARS SPACED @ 0.60M

10mm $\varnothing$ TRAVERSE BARS SPACED EVERY 0.40m

10mm $\varnothing$ TRAVERSE BARS SPACED EVERY 0.40m

10mm DIA. VERTICAL BARS SPACED @ 0.60M

10mm DIA. HOR BARS @ EVERY 3 LAYERS OF CHB

10mm DIA. VERTICAL BARS SPACED @ 0.60M

10mm $\varnothing$ TRAVERSE BARS SPACED EVERY 0.40m

3 - 10mm $\varnothing$ MAIN BARS

4" CHB

10mm DIA. HOR BARS @ EVERY 3 LAYERS OF CHB

10mm DIA. VERTICAL BARS SPACED @ 0.60M

10mm $\varnothing$ TRAVERSE BARS SPACED EVERY 0.40m

10mm $\varnothing$ TRAVERSE BARS SPACED EVERY 0.40m

10mm DIA. VERTICAL BARS SPACED @ 0.60M

10mm DIA. HOR BARS @ EVERY 3 LAYERS OF CHB

10mm DIA. VERTICAL BARS SPACED @ 0.60M

10mm $\varnothing$ TRAVERSE BARS SPACED EVERY 0.40m

3 - 10mm $\varnothing$ MAIN BARS


4" CHB

10mm DIA. HOR BARS @ EVERY 3 LAYERS OF CHB

10mm DIA. VERTICAL BARS SPACED @ 0.60M











10mm $\varnothing$ TRAVERSE BARS SPACED EVERY 0.40m

REPUBLIC OF THE PHILIPPINES PROVINCE OF SOUTH COTABATO OFFICE OF THE PROVINCIAL ENGINEER PLANNING, PROGRAMMING & DESIGN DIVISION KORONADAL, CITY	PROJECT TITLE & LOCATION: CONSTRUCTION OF TWO (2) CLASSROOM BUILDING WITH ATTACHED TOILET Ubo Elementary School-Lambert Extension, Brgy. Lamberton, Lala School, South Cotabato	DRAFTED BY: JHICOR L. EMBAGSON, UAP ARCHITECT (U.O.)	PREPARED BY: KRISTY B. SERBANEZ ENGINEER	CHECKED BY: GLENDALE B. MARFIL, UAP ARCHITECT III-VERTICAL SECTION HEAD	SUBMITTED BY: FREDERICK D. SORIANO MPA HEAD, Planning, Prog & Designing Division	RECOMMENDING APPROVAL: MARNIL O. ABEROCHO, MPA PROVINCIAL ENGINEER	APPROVED: REYNALDO S. TAMAYO, JR. PROVINCIAL GOVERNOR	SHEET NO: S 2 10/22
---	--	---	---	--	---	---	--	------------------------------------

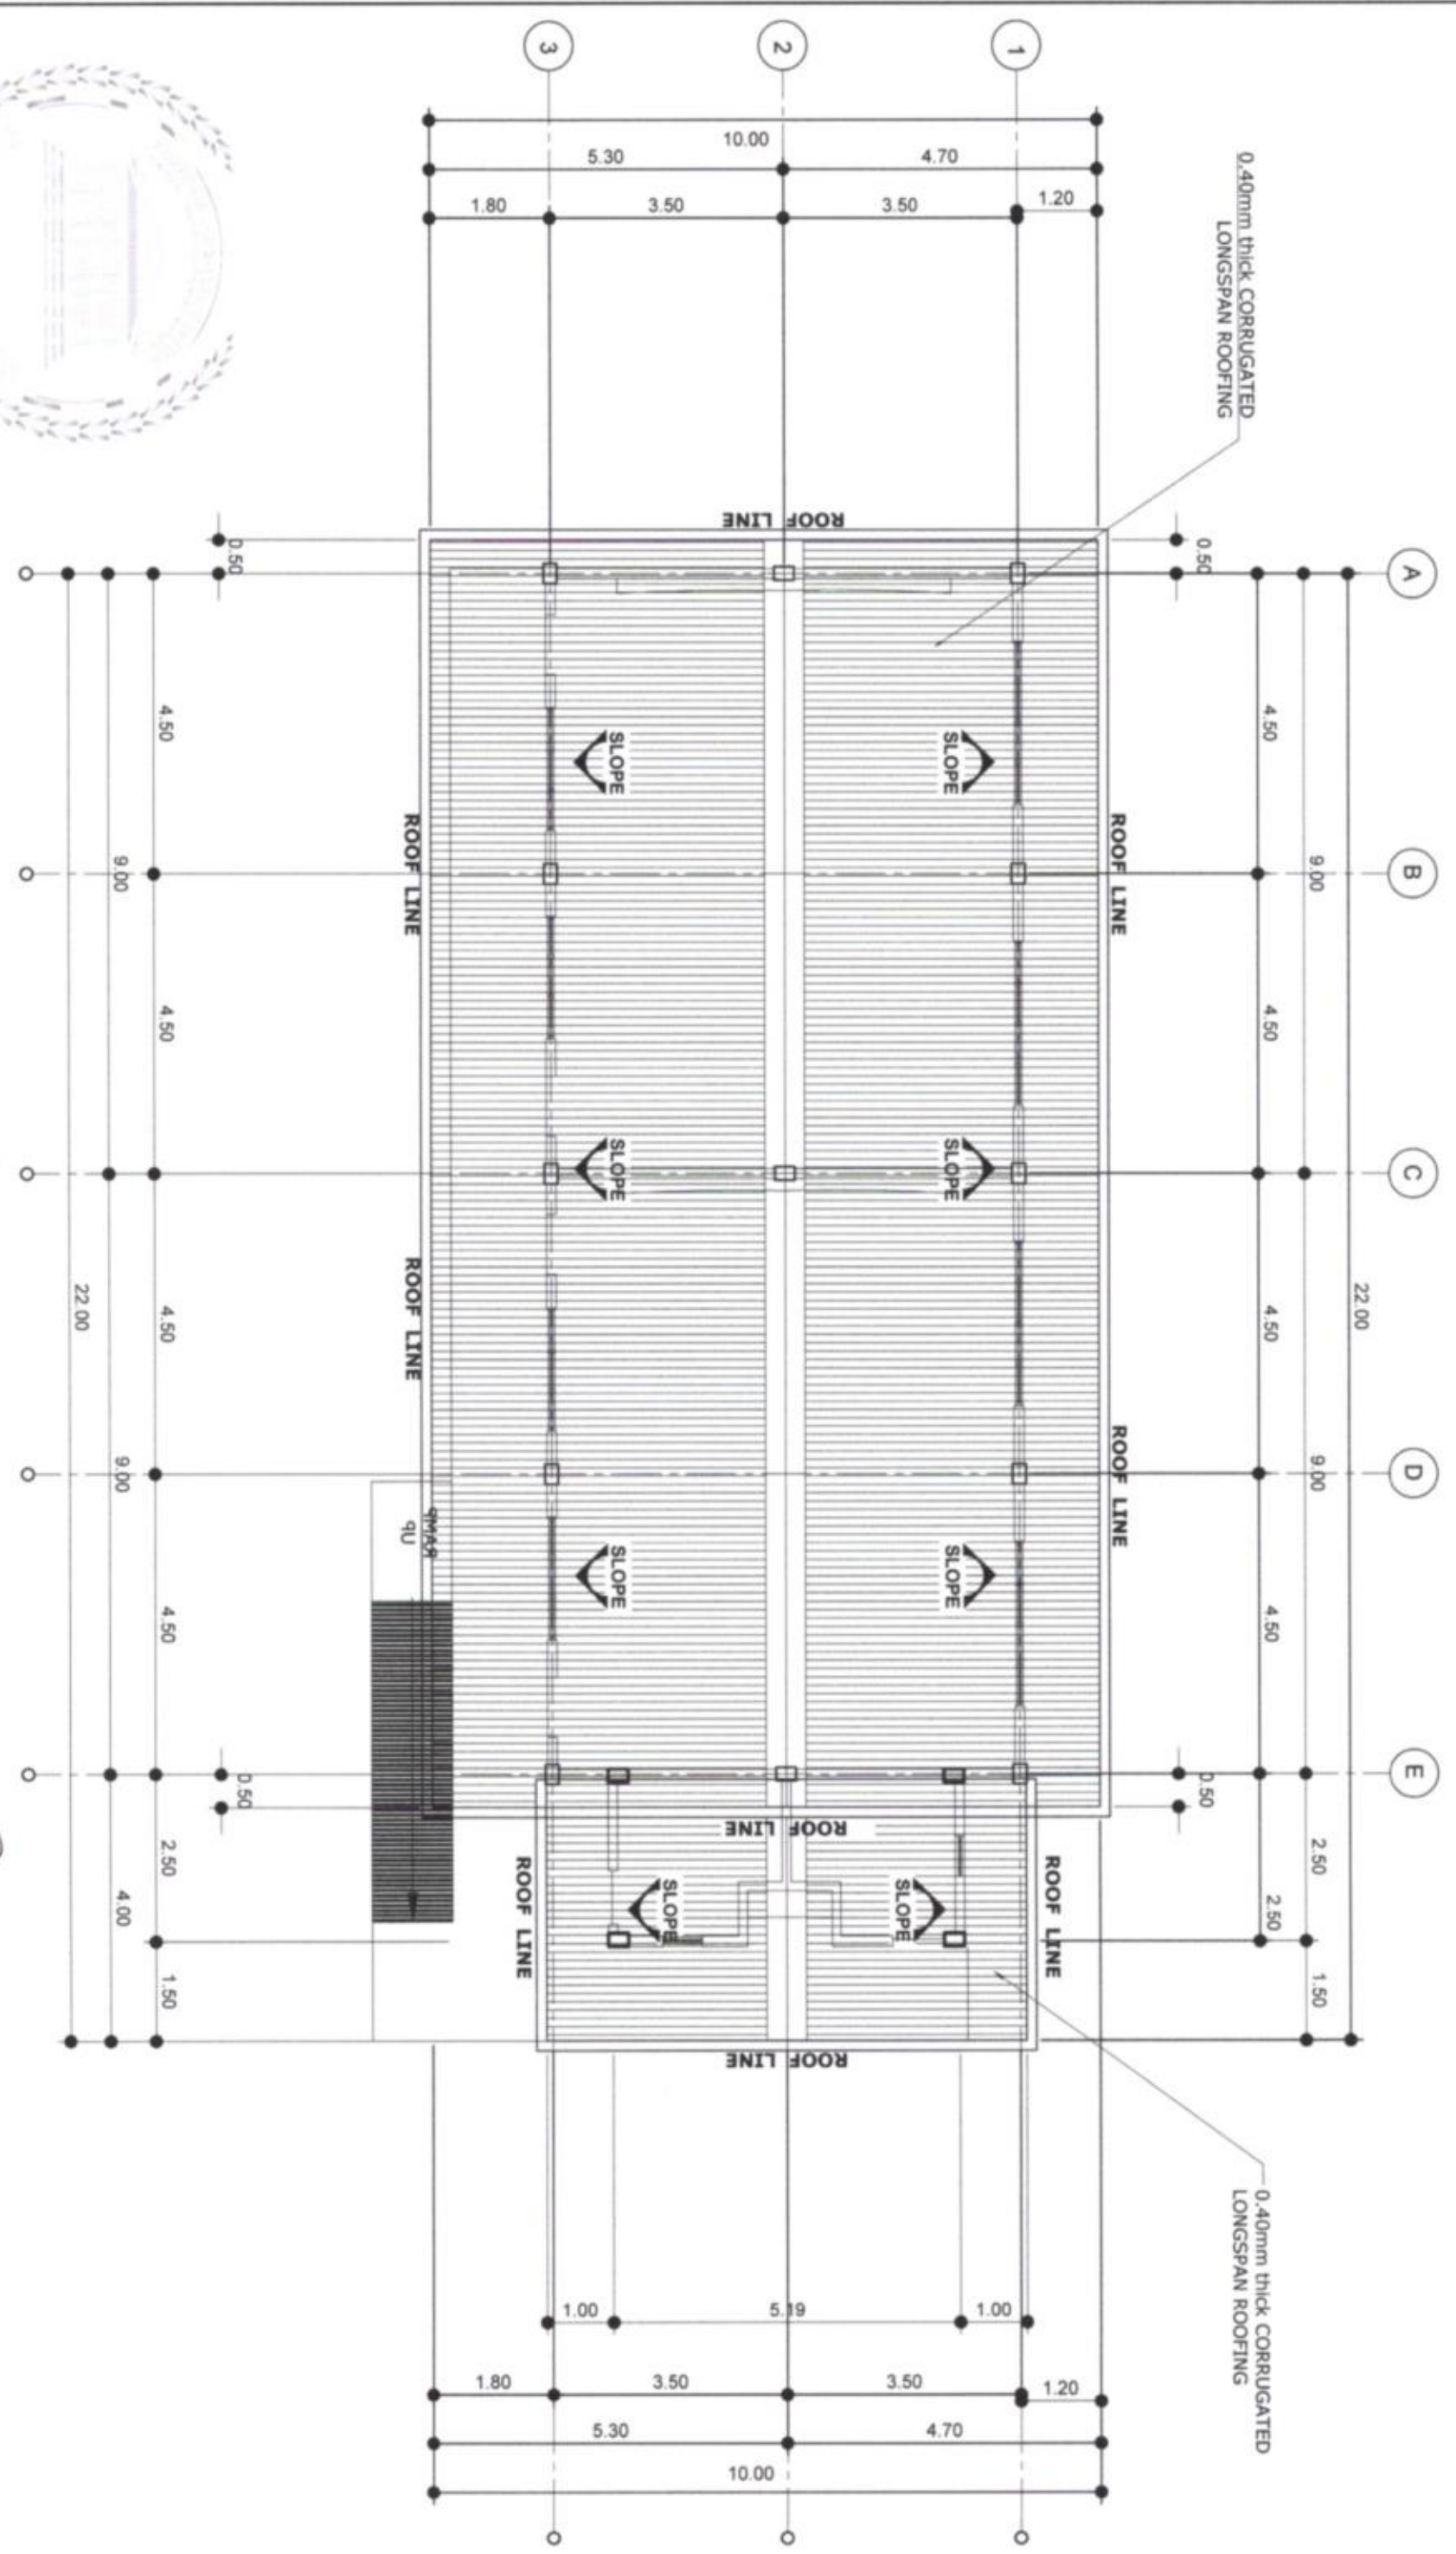


ROOF PLAN
SCALE: 1:100
MTS


REPUBLIC OF THE PHILIPPINES PROVINCE OF NORTH COTABATO OFFICE OF THE PROVINCIAL ENGINEER PLANNING, PROGRAMMING & DESIGNING DIVISION KORONADAL CITY	PROJECT TITLE & LOCATION: CONSTRUCTION OF TWO (2) CLASSROOM BUILDING WITH ATTACHED TOILET Ubo Elementary School-Lambert Extension, Brgy. Lamberto, Jolo City, South Cotabato	DRAFTED BY: JHICOR L. EMBAGON, UAP ARCHITECT (I.O.)	PREPARED BY: KRISHY ANN S. SERVANEZ ENGINEER I	CHECKED BY: GLENDALE B. MARFIL, UAP ARCHITECT III- VERTICAL SECTION HEAD	SUBMITTED BY: FREDERICK T. SORIANO, MPA HEAD, Planning, Prog & Designing Division	RECOMMENDING APPROVAL: MARNILLO S. SORIANO, MPA PROVINCIAL ENGINEER	APPROVED: REYNALDO S. TAMAYO, JR. PROVINCIAL GOVERNOR	SHEET NO: S 3 1122
--	--	---	--	--	---	---	---	--------------------------

 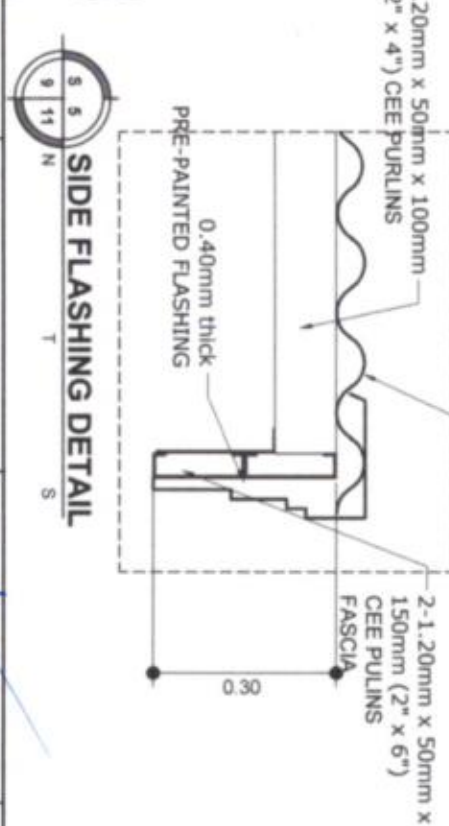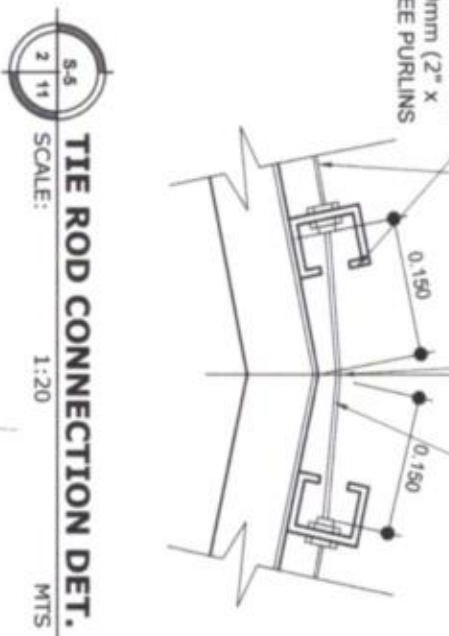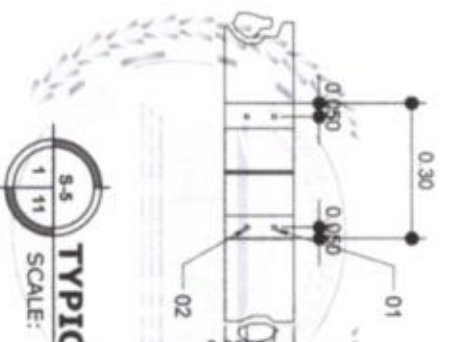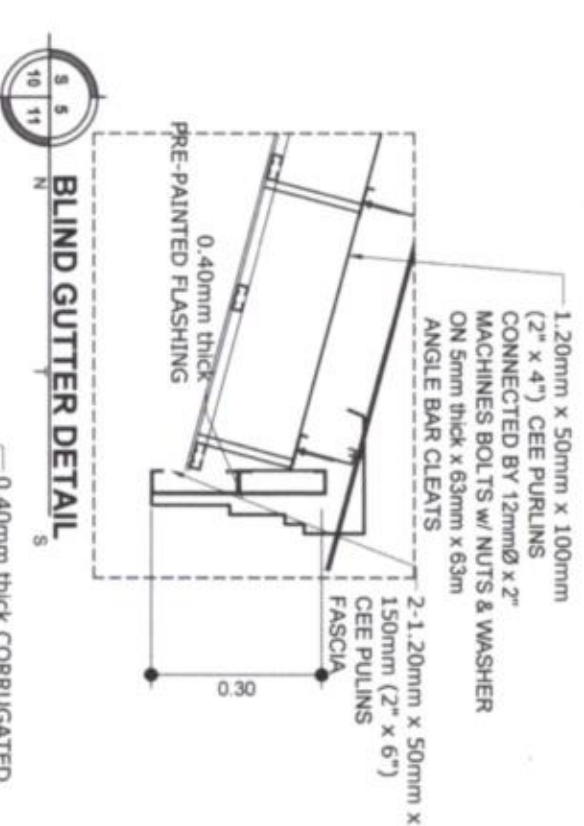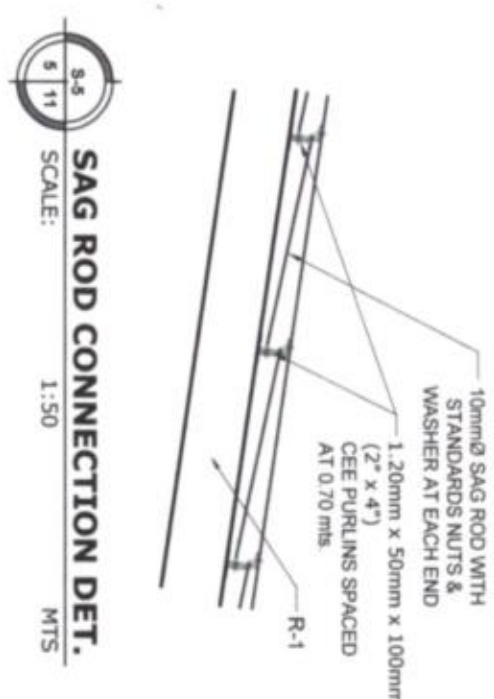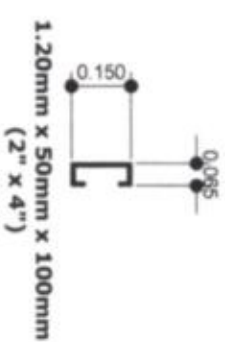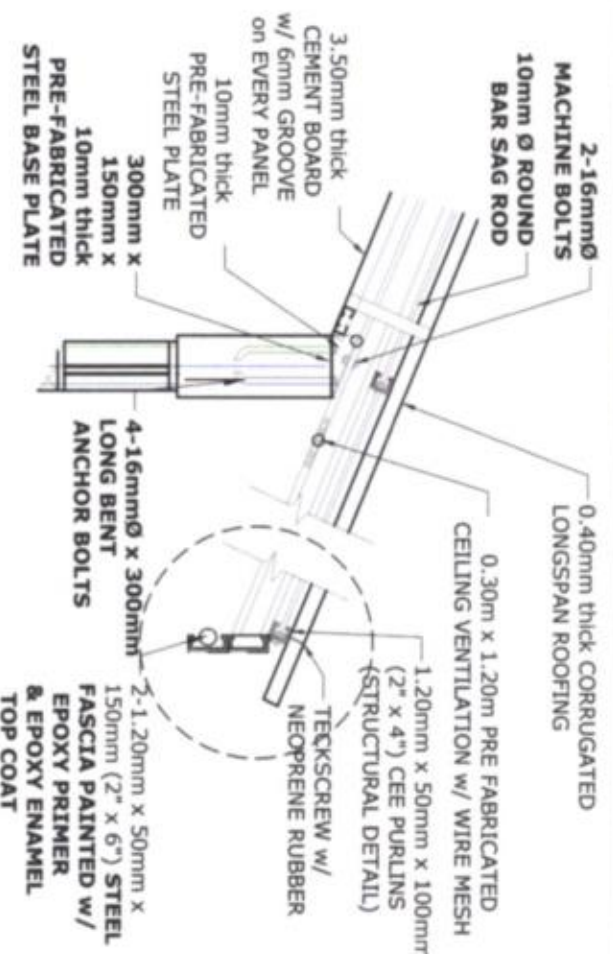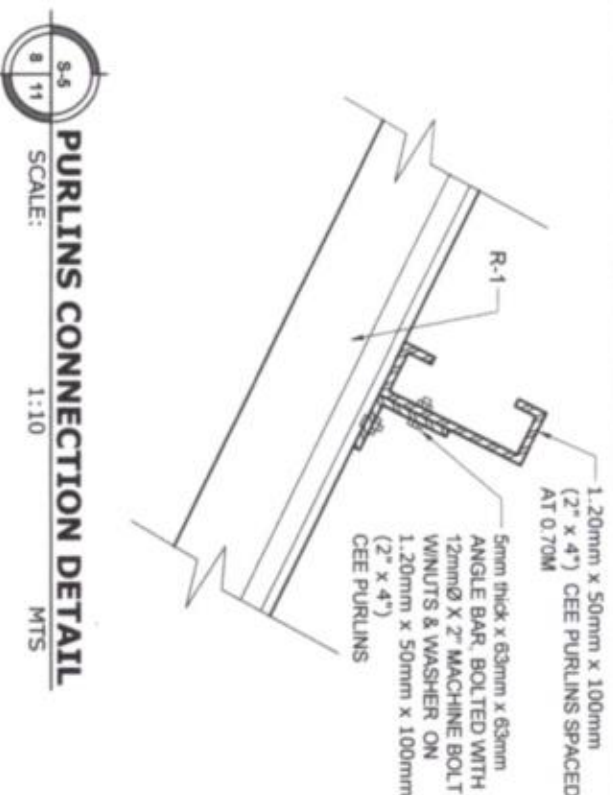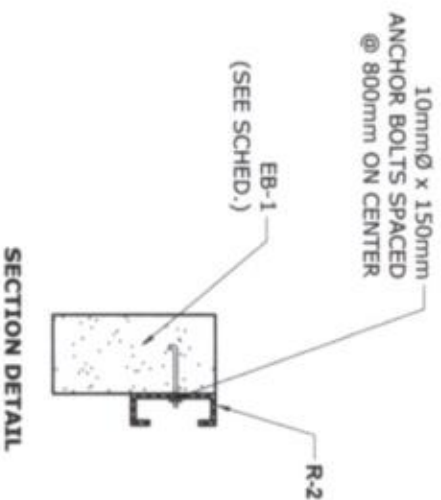

W.C.	WATER CLOSET
LAV.	LAVATORY
F.	Faucet
F.D.	FLOOR DRAIN
C.O.	CLEAN OUT
S.V.	SEPTIC VAILT
R.V.	RELIEF VENT
C.B.	CATCH BASIN
G.V.	GATE VALVE
S.S.	SOIL STACK
C.V.	CHECK VALVE
S.V.	STACK VENT
V.S.	VENT STACK
SHO.	SHOWER

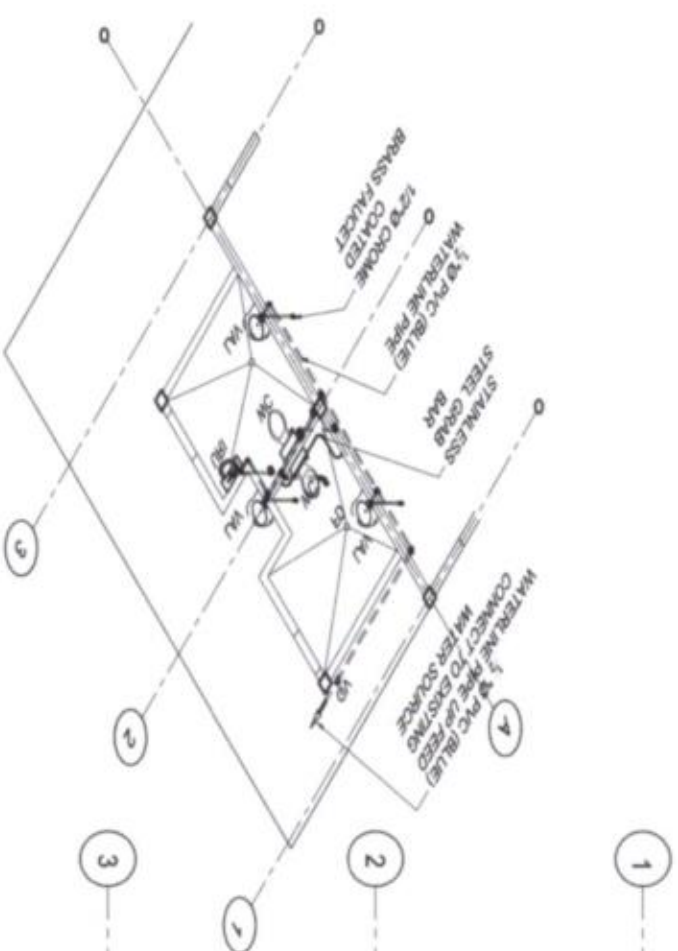

WATER LINE ISOMETRIC LAY-OUT
SCALE: 1:100 MTS.

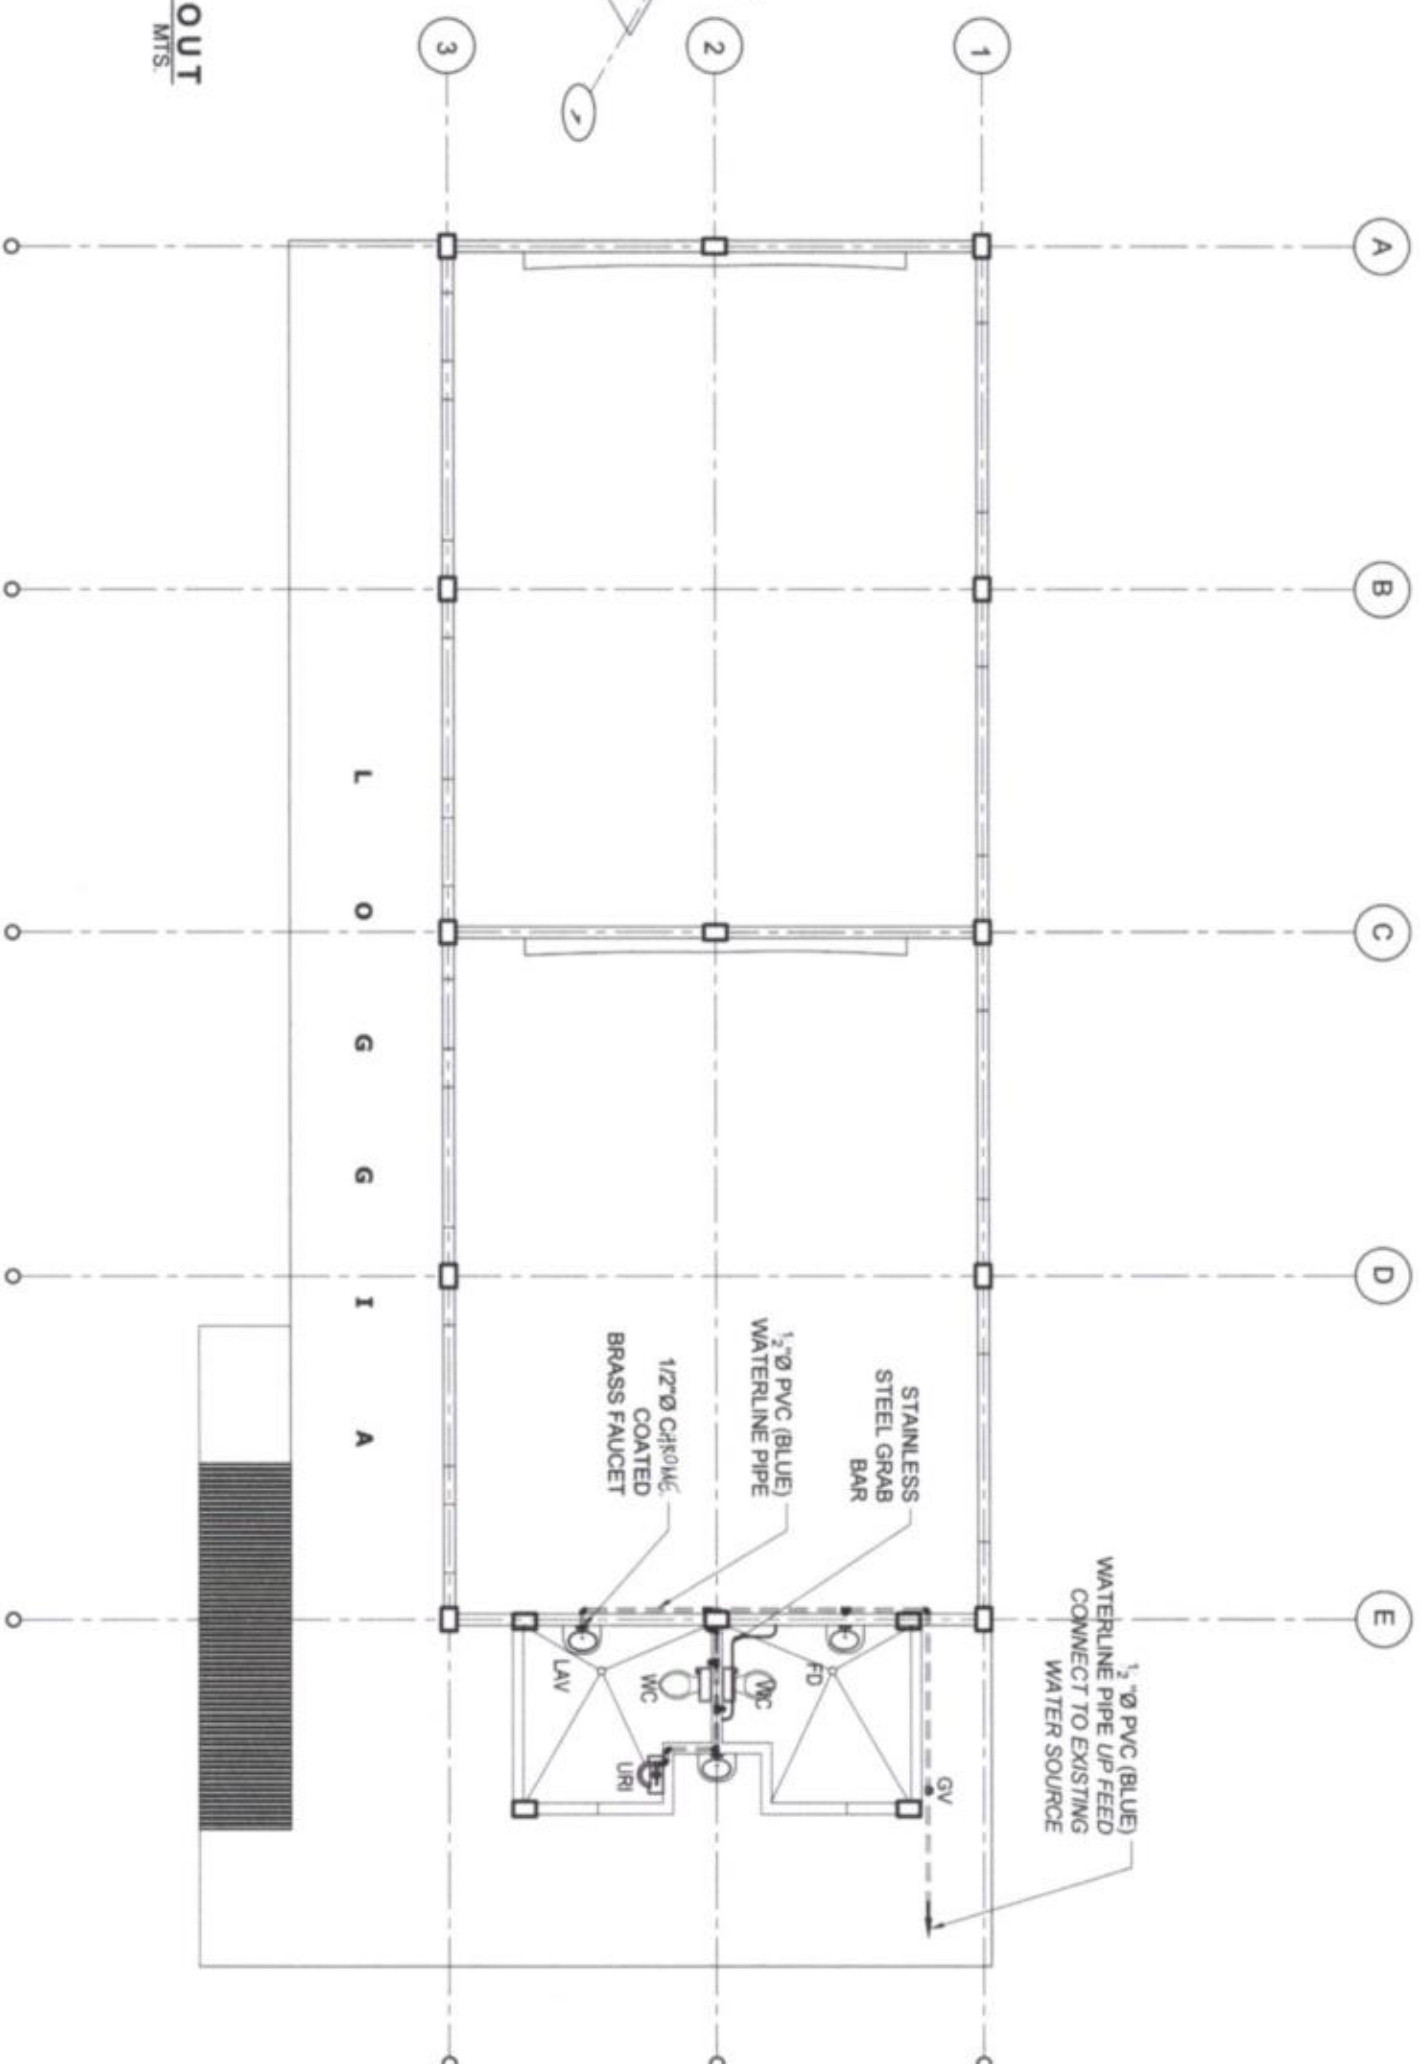


WATER LINE LAY-OUT
SCALE: 1:100 MTS.




 OFFICE OF THE PROVINCIAL ENGINEER PROVINCE OF SOUTH COTABATO PLANNING, PROGRAMMING & DESIGNING DIVISION KORONAADAL CITY	PROJECT TITLE & LOCATION:	DRAFTED BY:	PREPARED BY:	CHECKED BY:	SUBMITTED BY:	RECOMMENDING APPROVAL:	APPROVED:	SHEET NO.
	CONSTRUCTION OF TWO (2) CLASSROOM BUILDING WITH ATTACHED TOILET Ubo Elementary School-Lambingan Extension, Barang Lambingan, Ubo Subo, South Cotabato	JHICOR L. FAULCON, UAP ARCHITECT (U.O)	KRISTIAN S. ARANUEZ ENGINEER I	GLENDALIE B. MARFIL, UAP ARCHITECT III (VERTICAL SECTION HEAD)	FREDERICK GORRARD, MPA HEAD, Planning, Prog & Designing Division	MARTINLOS SIBERONGOT, MPA PROVINCIAL ENGINEER	REYNALDO S. TAMAYO, JR. PROVINCIAL GOVERNOR	P 1 1422

- LEGEND:**
- W.C. WATER CLOSET
 - LAV. LAVATORY
 - F. FAUCET
 - F.D. FLOOR DRAIN
 - C.O. CLEAN OUT
 - S.V. SEPTIC VAULT
 - R.V. RELIEF VENT
 - C.B. CATCH BASIN
 - G.V. GATE VALVE
 - S.S. SOIL STACK
 - C.V. CHECK VALVE
 - S.V. STACK VENT
 - V.S. VENT STACK
 - SHO. SHOWER

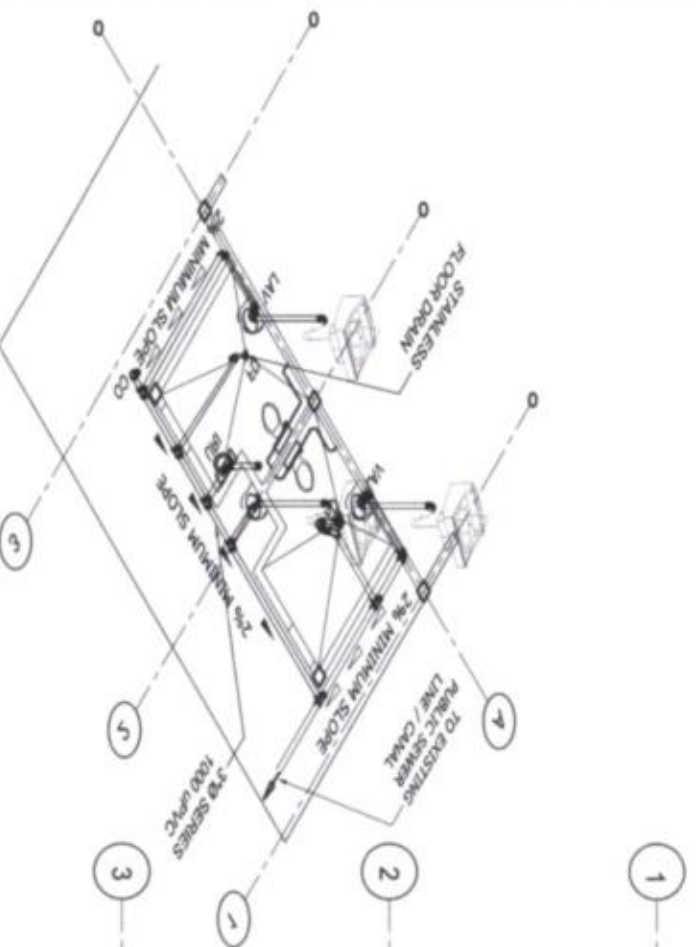

WASTE WATER LINE ISOMETRIC LAY-OUT
SCALE: 1:100 MTS.

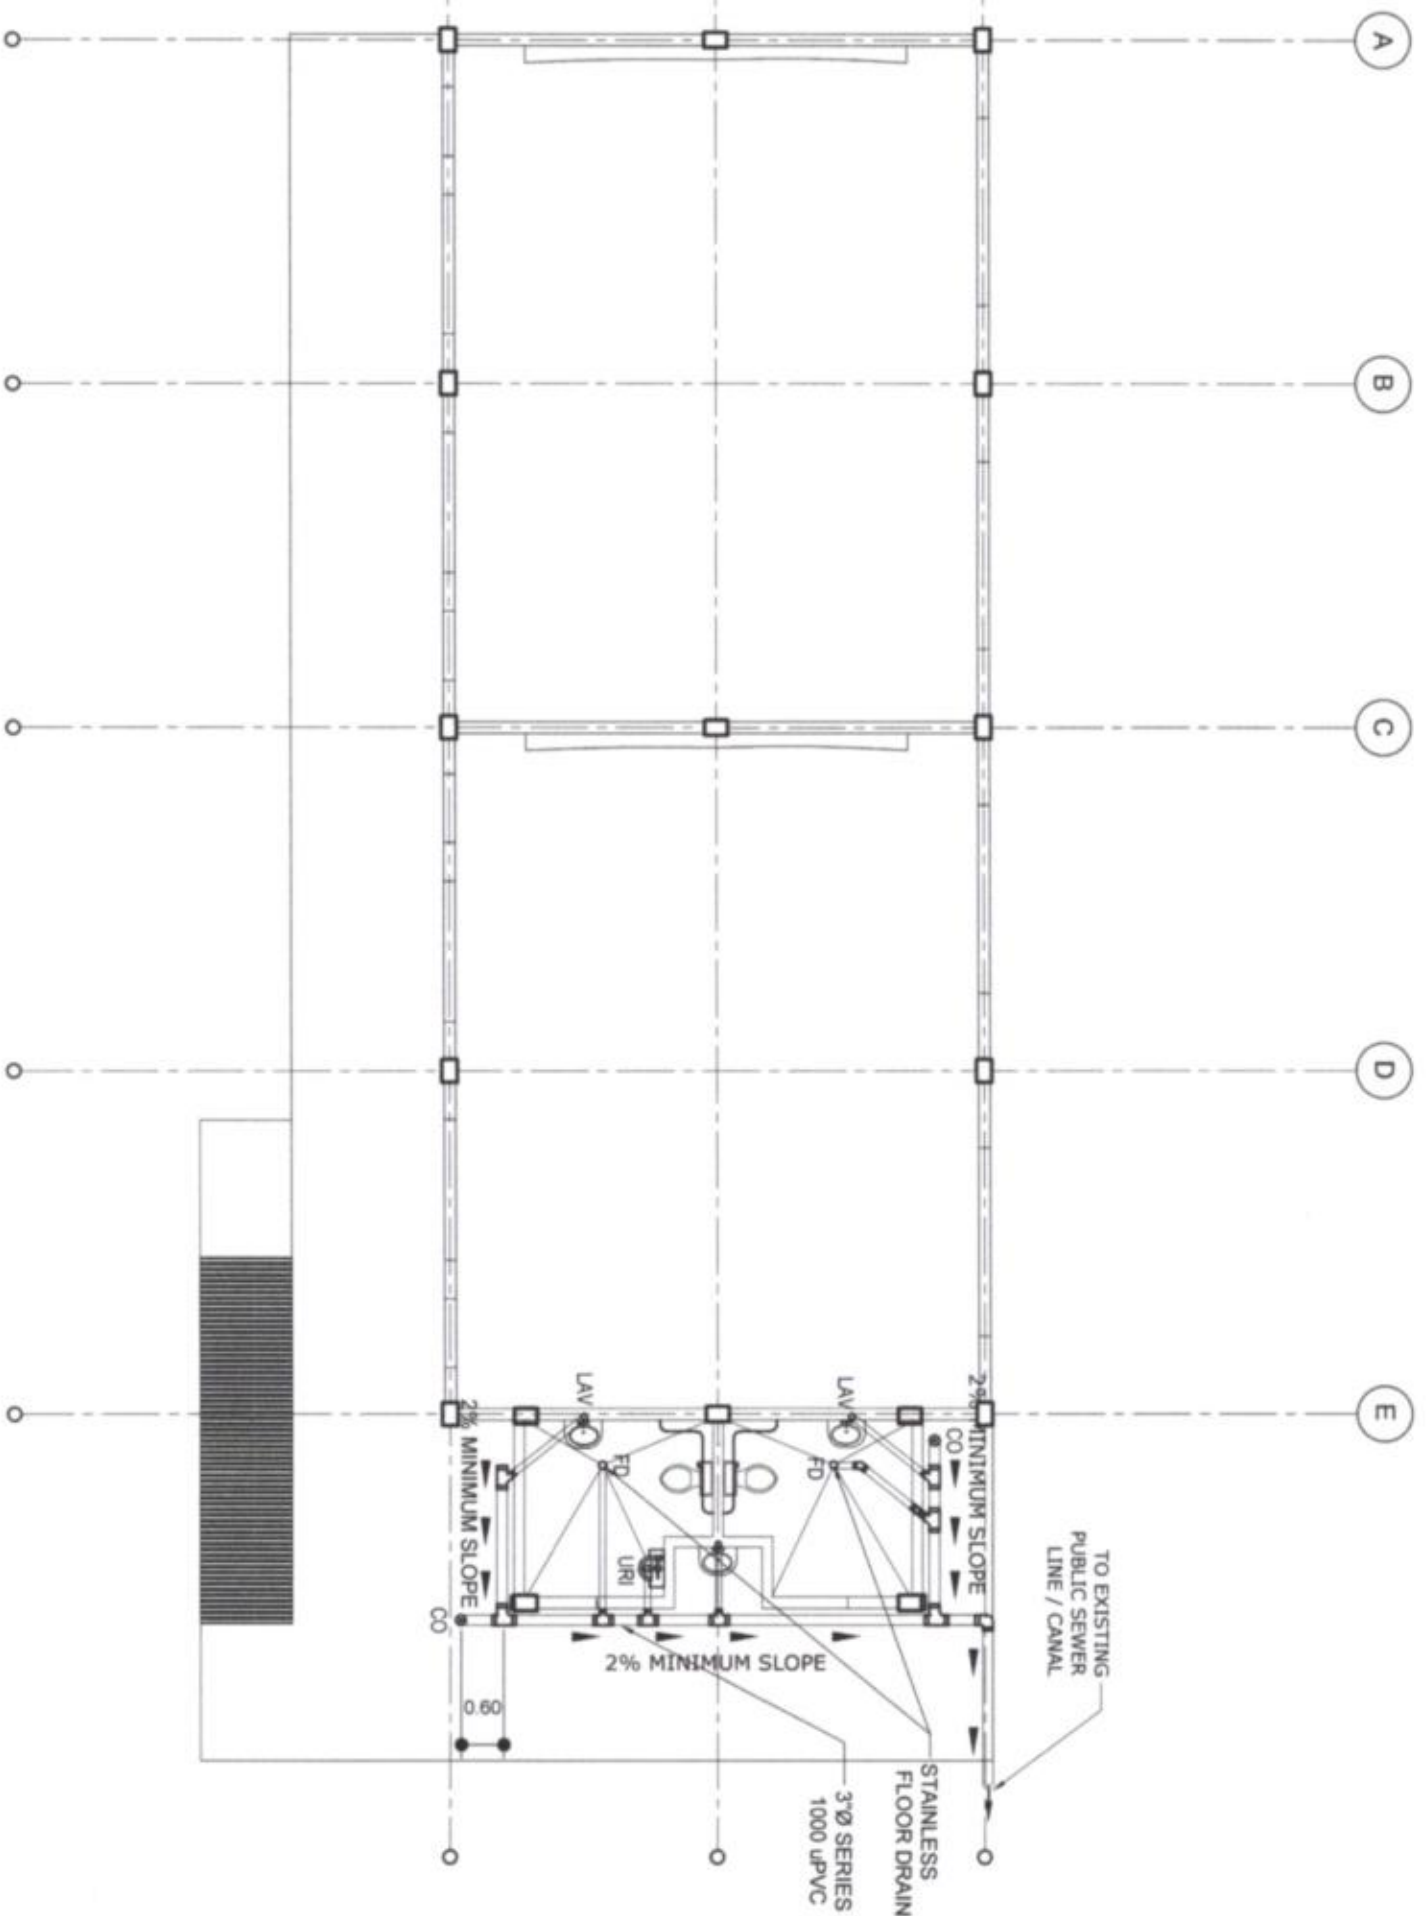

WASTE WATER LINE LAY-OUT
SCALE: 1:100 MTS.



OFFICE OF THE PROVINCIAL ENGINEER
PROVINCE OF SOUTH COTABATO
PLANNING, PROGRAMMING & DESIGNING DIVISION
KORONADAL CITY

PROJECT TITLE & LOCATION:
CONSTRUCTION OF TWO (2) CLASSROOM
BUILDING WITH ATTACHED TOILET
Ubo Elementary School, Lantawan Extension,
Brgy. Lantawan, Lala, South Cotabato

DRAFTED BY:
JHICOR L. FARIJAGON, UAP
ARCHITECT (U.O.)

PREPARED BY:
KRISTY ANN S. SERVAZ
ENGINEER


CHECKED BY:
GLENDALE B. MARFIL, UAP
ARCHITECT (B) VERTICAL SECTION HEAD

SUBMITTED BY:
FREDERICK D. SOLIANO, MPA
HEAD, Planning, Prog's & Designing Division

RECOMMENDING APPROVAL:
MARINILLO S. PEROCCHO, MPA
PROVINCIAL ENGINEER

APPROVED:
REYNALDO S. TAMAYO, JR.
PROVINCIAL GOVERNOR

SHEET NO.
P 2
15/22

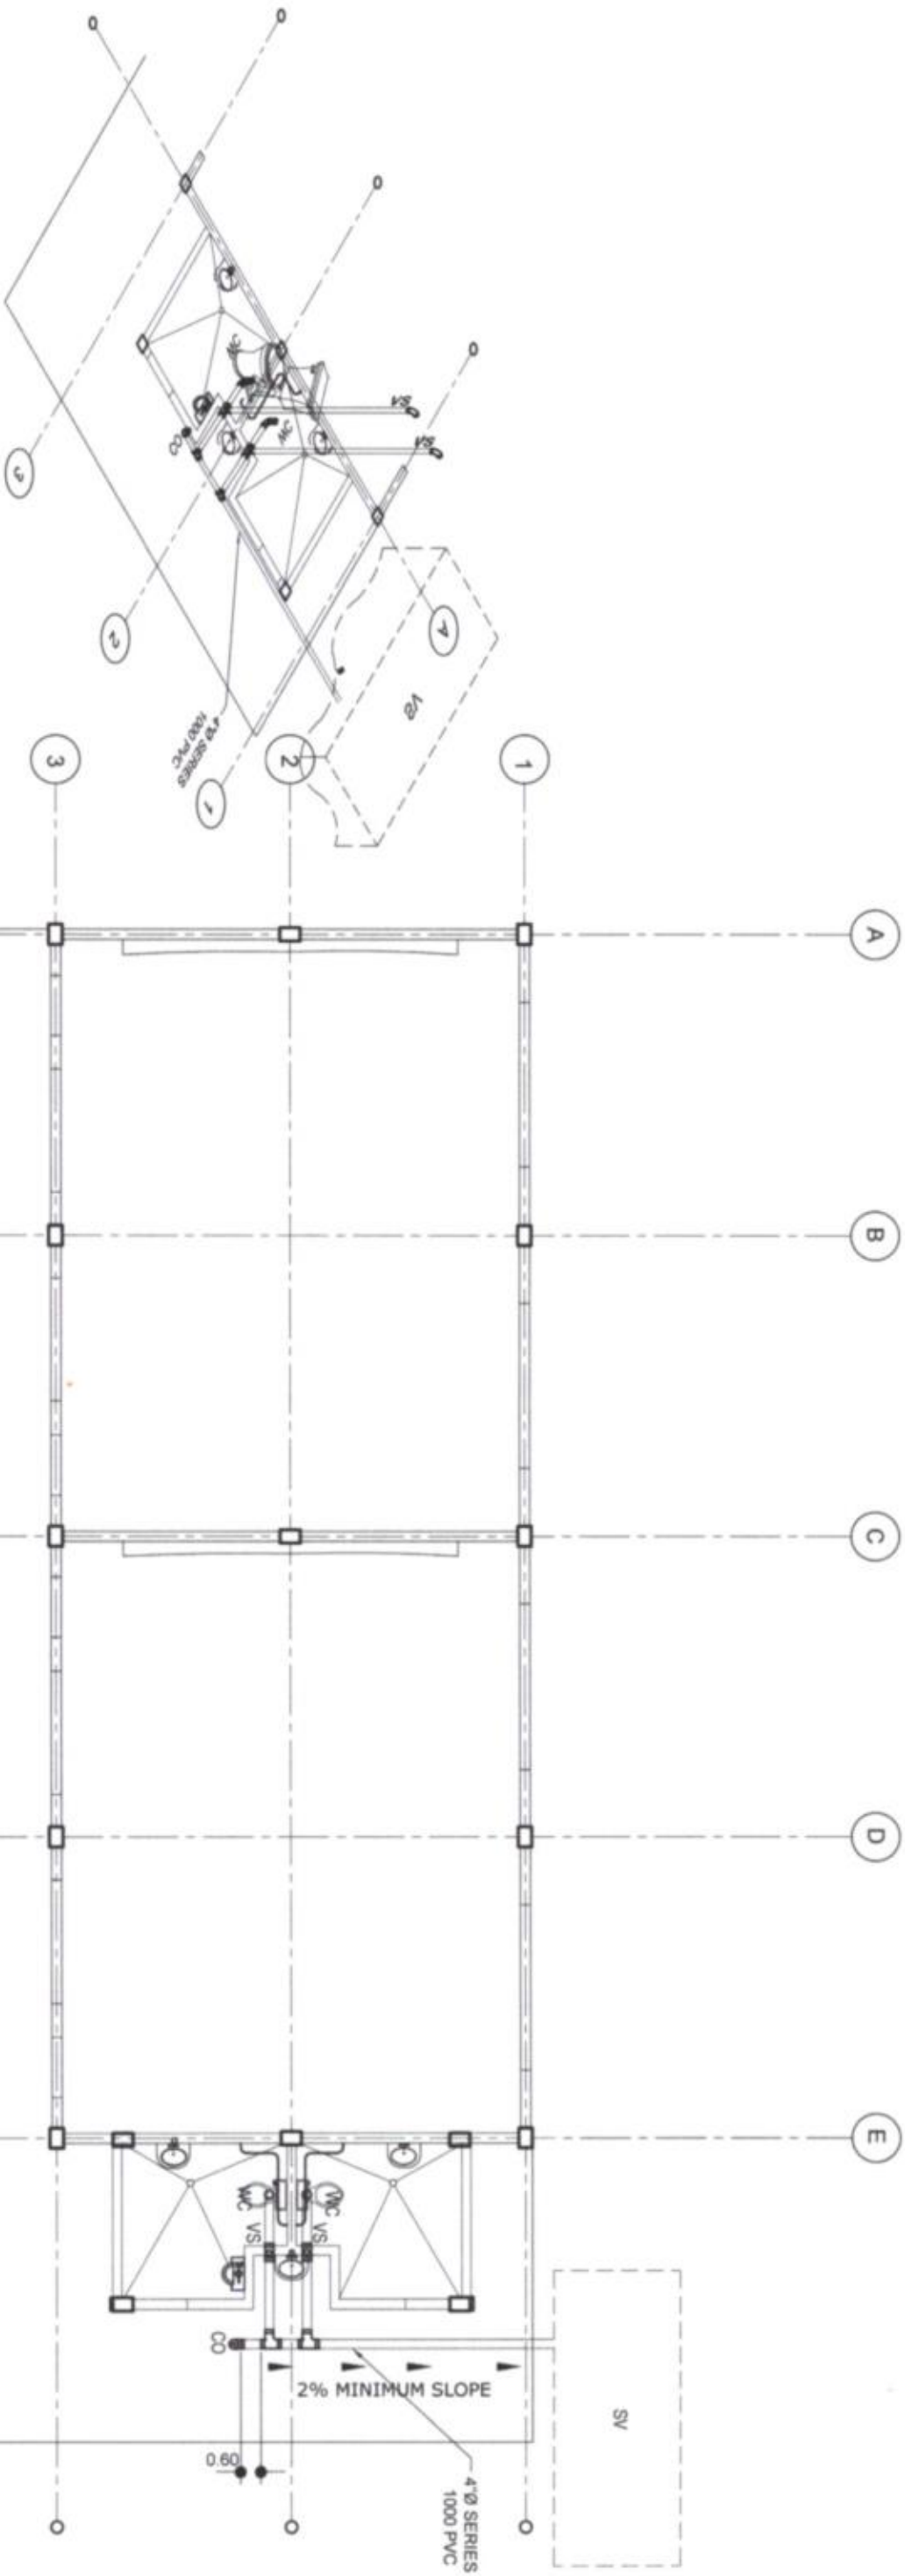

SOIL PIPING ISOMETRIC LAY-OUT
SCALE: 1:100 MTS.



SOIL PIPING LAY OUT
SCALE: 1:100 MTS.

REPUBLIC OF THE PHILIPPINES PROVINCE OF SOUTHERN COTABATO OFFICE OF THE PROVINCIAL ENGINEER PLANNING, PROGRAMMING & DESIGNING DIVISION KOROYANAL CITY		PROJECT TITLE & LOCATION: CONSTRUCTION OF TWO (2) CLASSROOM BUILDING WITH ATTACHED TOILET Udo Elementary School-Lamitan Extension, Brgy. Lamigan, Lalaor Subd., South Cotabato		DRAFTED BY: JHICOR L. FANUGON, UAP ARCHITECT (I.O.)	PREPARED BY: KRISTIAN S. SERVANEZ ENGINEER I	CHECKED BY: GLENDAL B. MARTEL, UAP ARCHITECT III, VERTICAL SECTION HEAD	SUBMITTED BY: FREDERICO SORIANO MPA HEAD, Planning, Prog & Designing Division	RECOMMENDING APPROVAL: MARINIO S. DEERONG, MPA PROVINCIAL ENGINEER	APPROVED: REYNALDO S. TAMAYO, JR. PROVINCIAL GOVERNOR	SHEET NO: P 3 16/22
--	--	---	--	--	---	--	--	---	--	---------------------------

SPECIFICATIONS:

ALL PLUMBING WORKS AND INSTALLATION SHALL BE DONE IN ACCORDANCE WITH THE NATIONAL PLUMBING CODE OF THE PHIL. AND THE LOCAL PLUMBING CODE REQUIRED.

PROVIDE 3/4" DIA. GATE VALVE FOR WATER SUPPLY FROM WATER SOURCE.

ALL PVC AND G.I. PIPE TO BE USED SHALL BE BRAND NEW AND HIGH QUALITY STANDARD AND APPROVED FOR BOTH LOCATION AND PURPOSES.

ALL CLEAN OUT SHALL BE FLUSHED MOUNTED ON FLOOR EXCEPT AT AREAS SUBJECTED TO TRAFFIC WHICH SHALL BE FLUSHED TO WALL, PROVIDE COVER CAPS.

THE SLOPE OF SEWER LINE SHALL BE 2% FOR DRAIN LINE, IT SHALL BE 1% FOR THE INLET PIPE. THE INLET PIPE SHALL BE 2" HIGHER THAN SIPHON PIPE. PROVIDE VENT AS INDICATED.

ALL PLUMBING WORKS AND INSTALLATIONS SHALL BE DONE UNDER THE DIRECT SUPERVISION OF A LICENSED MASTER PLUMBER.

PLUMBING GENERAL NOTES:





PHILIPPINE PLUMBING CODE AND RULES AND REGULATIONS OF THE GOVERNMENT. COORDINATE DRAWING WITH OTHER RELATED DRAWINGS AND SPECIFICATIONS. THE ENGINEER SHALL BE NOTIFIED IMMEDIATELY OF ANY DISCREPANCY FOUND THEREIN. OTHER TRADES SHALL BE SUBJECT TO THE APPROVAL OF THE ARCHITECT AND / OR ENGINEER. ALL SLOPES FOR HORIZONTAL BRANCHES (SEWER) SHALL MAINTAIN 2% AS MINIMUM UNLESS NOTED OTHERWISE. ALL FIXTURES SHALL BE VENTED, UNLESS OTHERWISE INDICATED. ALL INDIVIDUAL BRANCHES TO FIXTURES OR GROUP OF FIXTURES OR EQUIPMENT SHALL BE PROVIDED WITH AIR CHAMBER.

LEGEND:


- | | |
|------|--------------|
| W.C. | WATER CLOSET |
| LAV. | LAVATORY |
| F. | FAUCET |
| F.D. | FLOOR DRAIN |
| C.O. | CLEAN OUT |
| S.V. | SEPTIC VAULT |
| R.V. | RELIEF VENT |
| C.B. | CATCH BASIN |
| G.V. | GATE VALVE |
| S.S. | SOIL STACK |
| C.V. | CHECK VALVE |
| S.V. | STACK VENT |
| V.S. | VENT STACK |
| SHO. | SHOWER |

NOTE:

ALL PIPE ROUGHING - IN INSTALLATION SHALL BE CHECKED BEFOREHAND BY THE DESIGNER & PROJECT ENGINEER PRIOR UPON SOLVENT CEMENT FIXED FASTENING & CONCEALING.

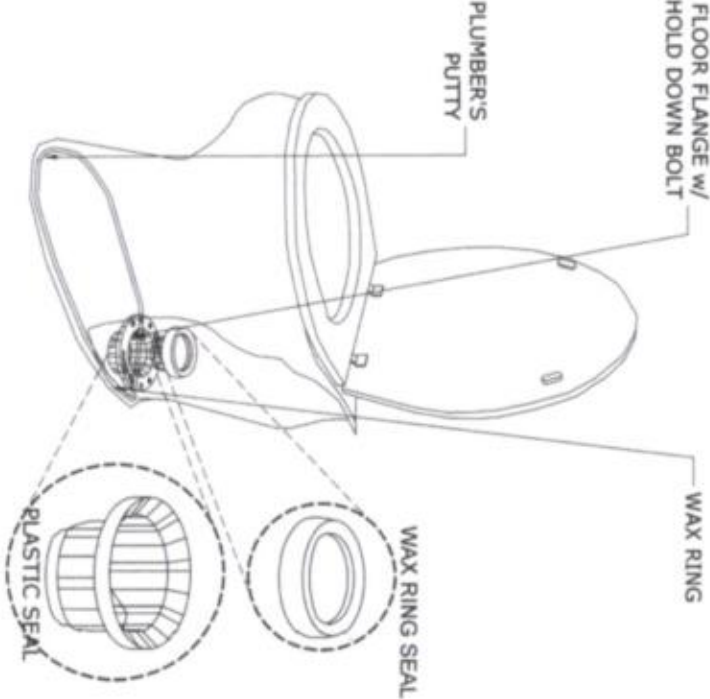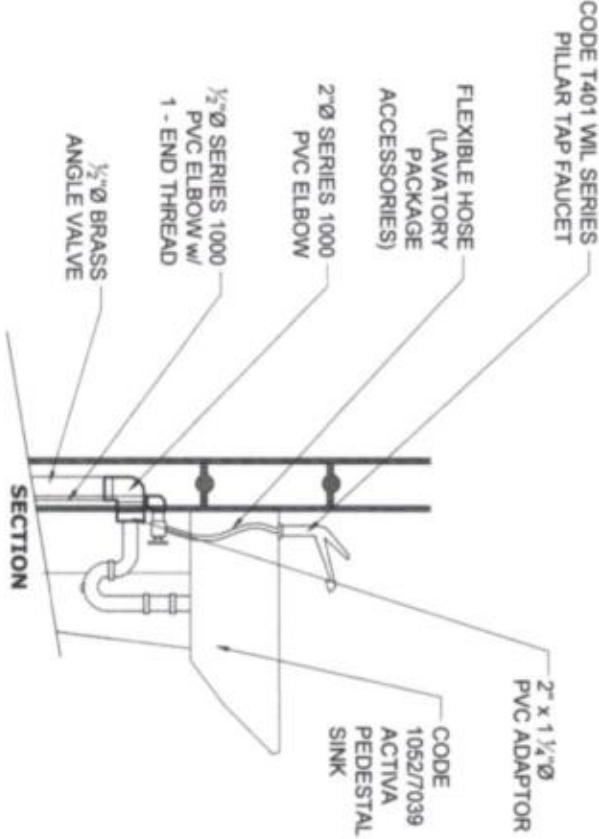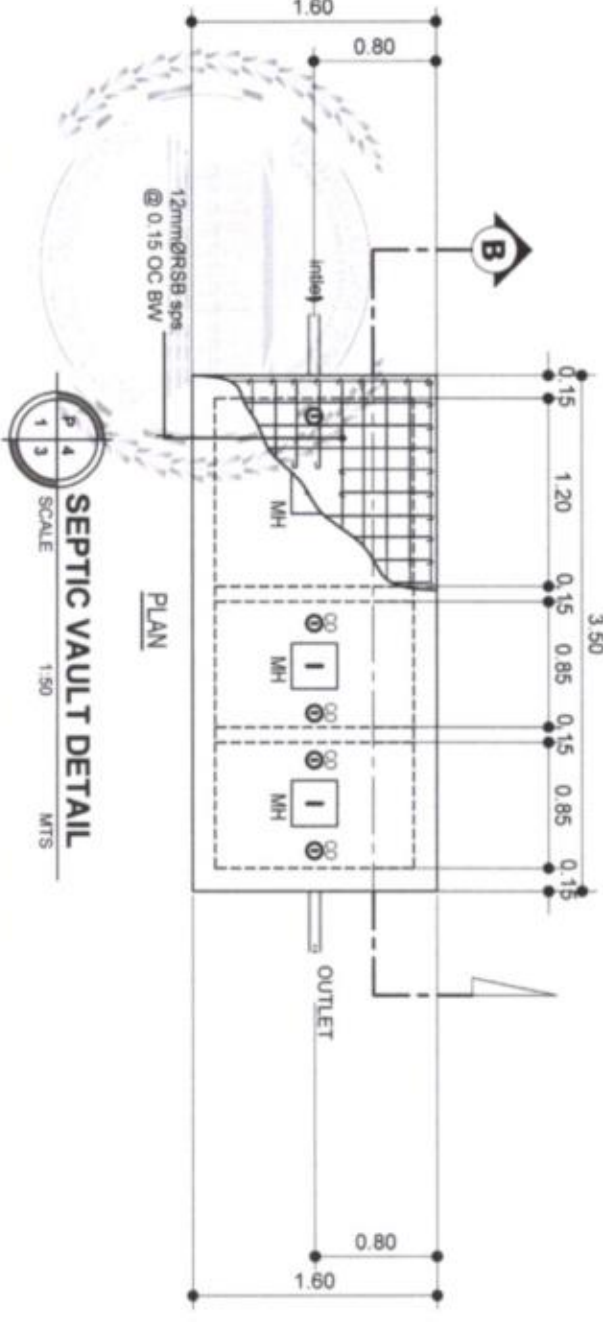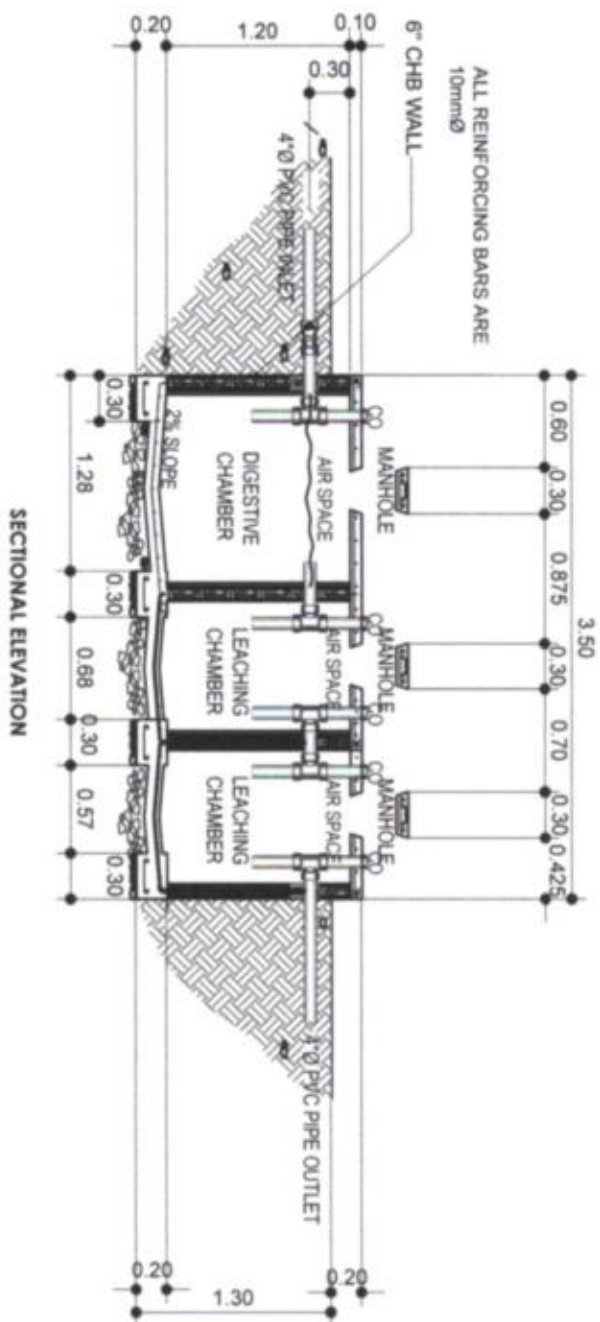


	PROJECT TITLE & LOCATION:		DRAFTED BY:	PREPARED BY:	CHECKED BY:	SUBMITTED BY:	RECOMMENDING APPROVAL:	APPROVED:	SHEET NO:
	CONSTRUCTION OF TWO (2) CLASSROOM BUILDING WITH ATTACHED TOILET		JHICOR, FABUGON, UAP	KRISTY ANN S. SERVANEZ	GLENDAL B. MARFIL, UAP	FREDERICK D. SOBRIANO, MPA	MARRILO S. DE ROSARIO, MPA	REYNALDO S. TAMAYO, JR.	P 4
	Ubo Elementary School-Lamitan Extension, Brgy. Lamigan Lake Sch, South Cotabato		ARCHITECT (U.O.)	ENGINEER	ARCHITECT (VERTICAL SECTION HEAD)	HEAD, Planning, Prog & Designing Division	PROVINCIAL ENGINEER	PROVINCIAL GOVERNOR	17/22
	OFFICE OF THE PROVINCIAL ENGINEER PROVINCE OF SOUTH COTABATO PLANNING, PROGRAMMING & DESIGNING DIVISION KORONADAL CITY								

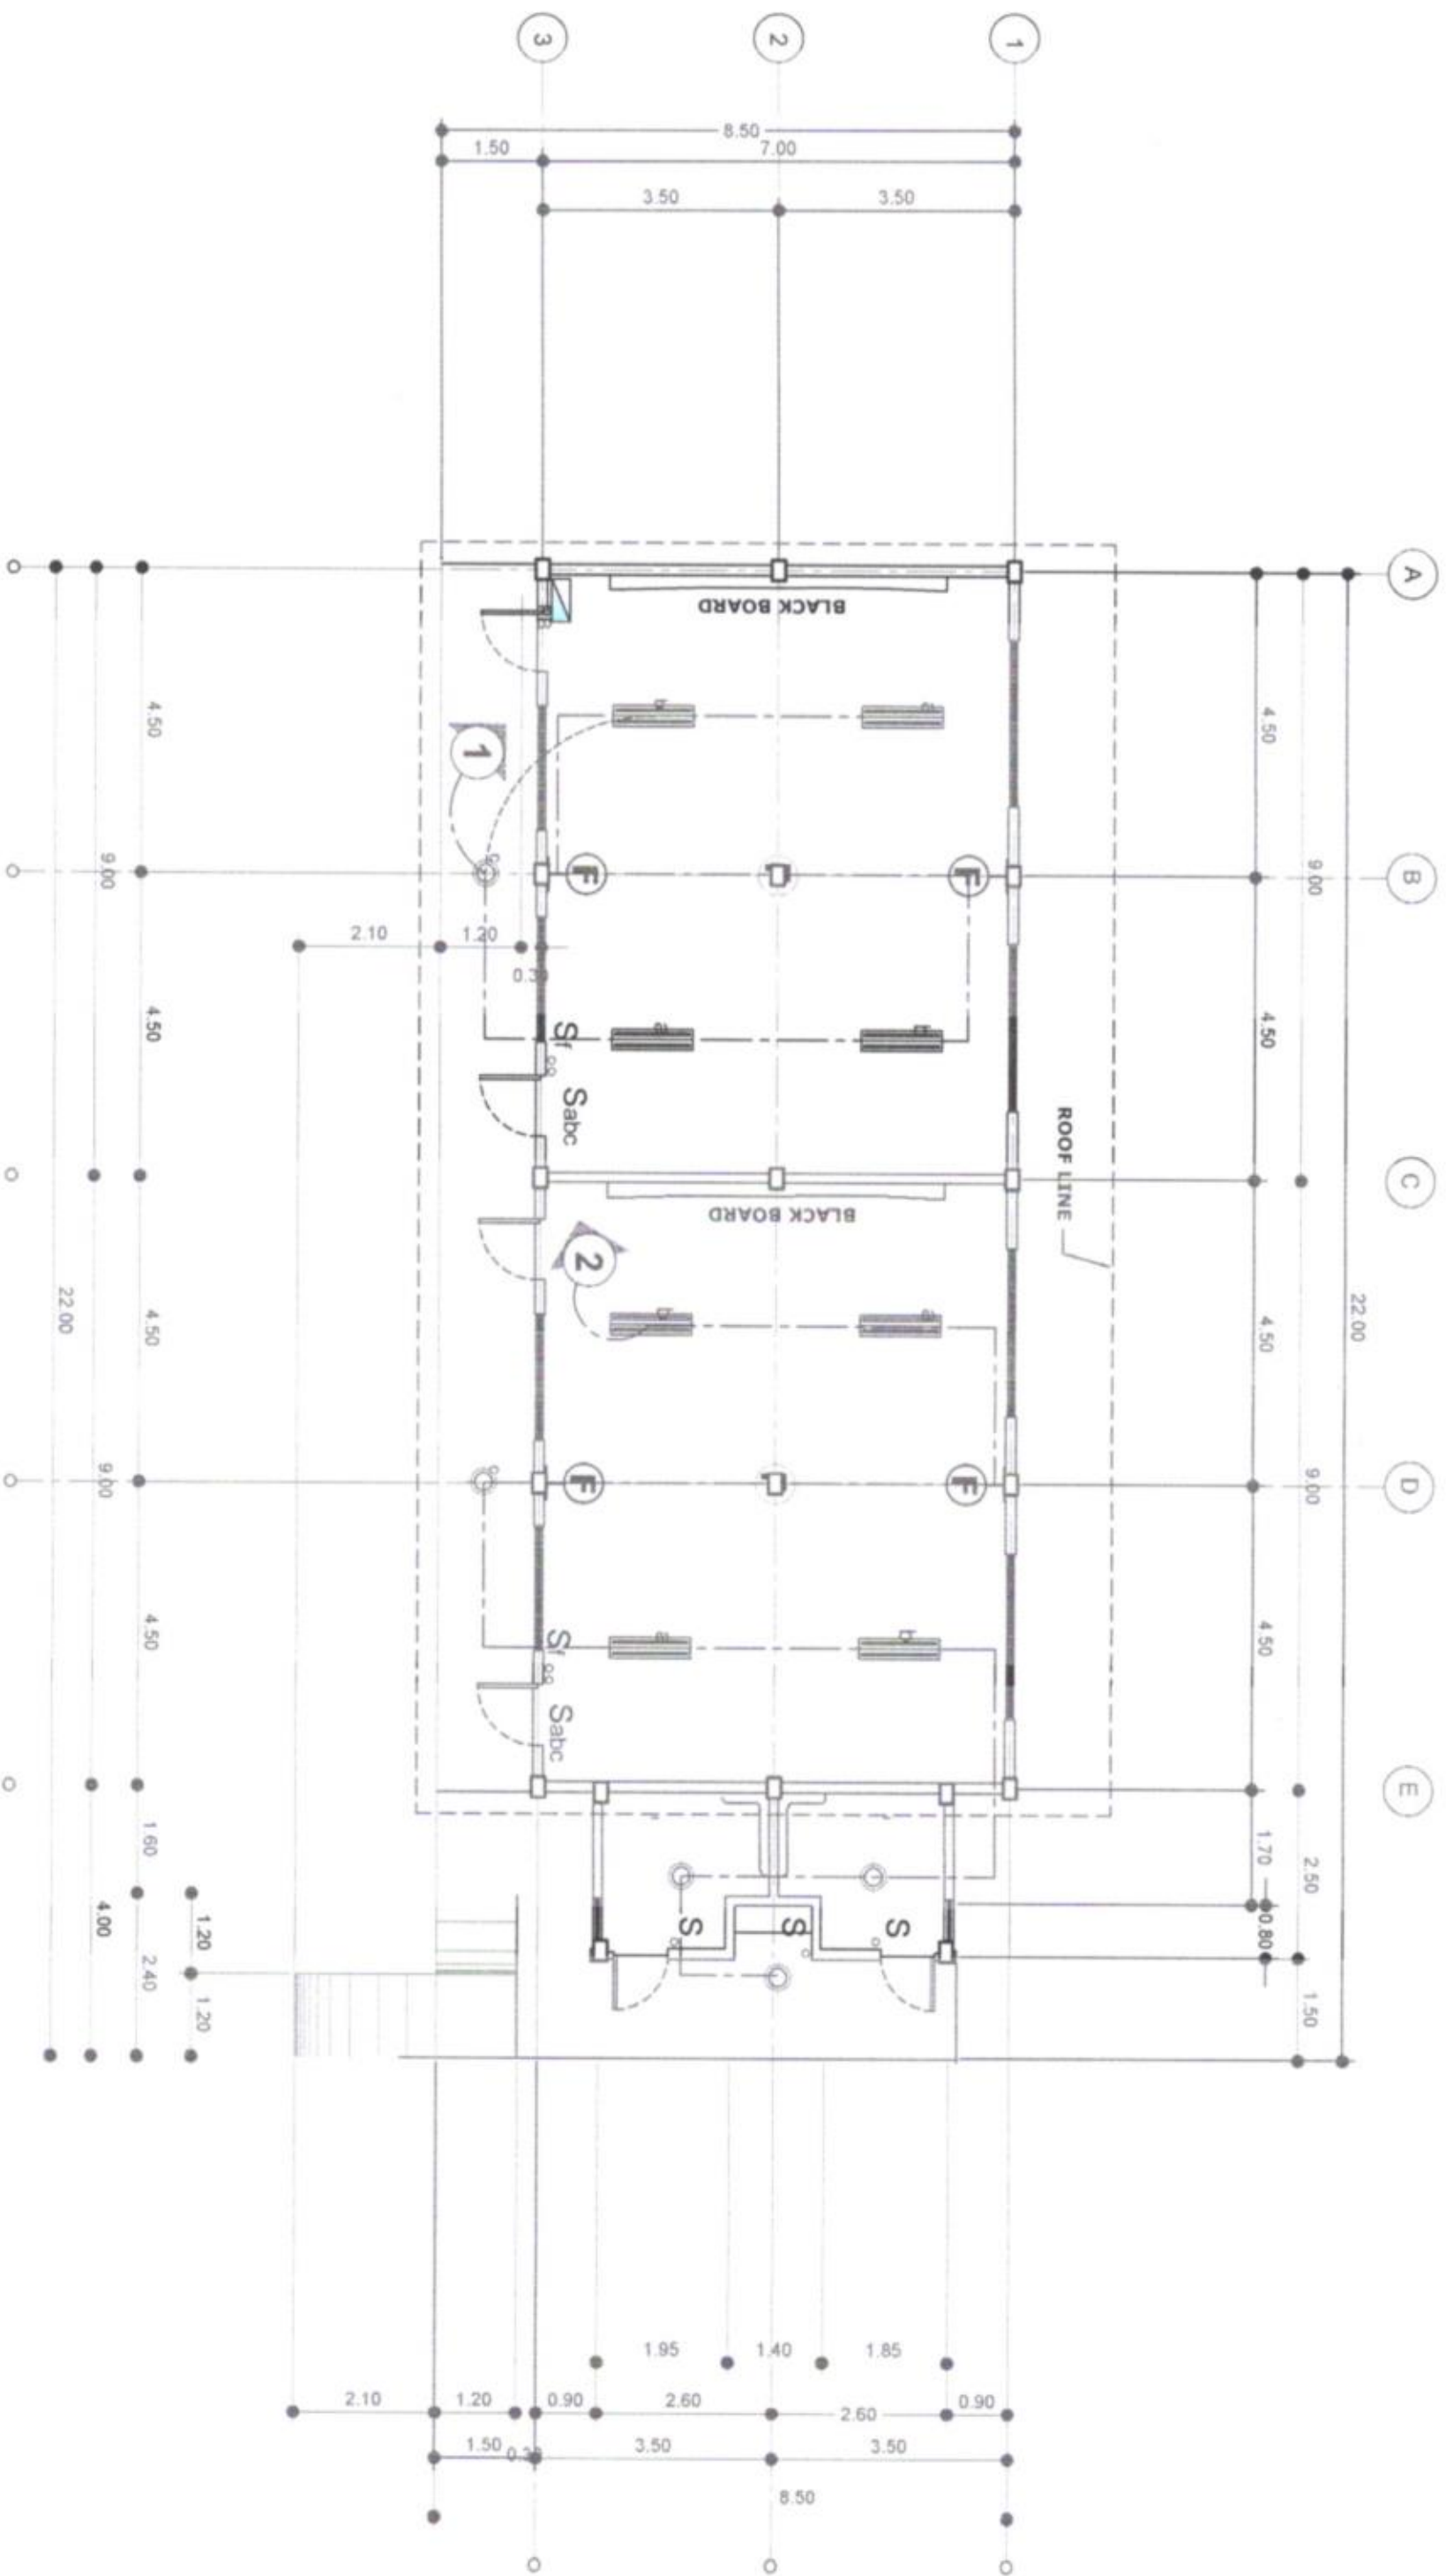

E-1 LIGHTING LAY-OUT PLAN
SCALE: 1:100 MTS

OFFICE OF THE PROVINCIAL ENGINEER PROVINCE OF NORTH COTABATO KORONADAL CITY	PROJECT TITLE & LOCATION: CONSTRUCTION OF TWO CLASSROOM (7x8m) BLDG. WITH ATTACHED TOILET	PREPARED BY: HELEN/LEA T. LINGAS ELEC. ENGINEER (JO)	CHECKED BY: EDUARDO S. CAMISURA, JR. ELEC. ENGINEER	CONFORMED BY: GLENDALE B. MARFIL, UAP ARCHITECT (Bldg. Section Chief)	CONFORMED BY:	SUBMITTED BY: FREDERICO S. SOMINO, MPA HEAD, Planning, Prog. & Designing Division	RECOMMENDING APPROVAL: MARNIL O. S. APEROCHO PROVINCIAL ENGINEER	APPROVED: REYNALDO S. TAMAYO, JR. PROVINCIAL GOVERNOR	SHEET NO: E-1 1820
--	--	---	--	--	----------------------	--	---	--	-----------------------------------

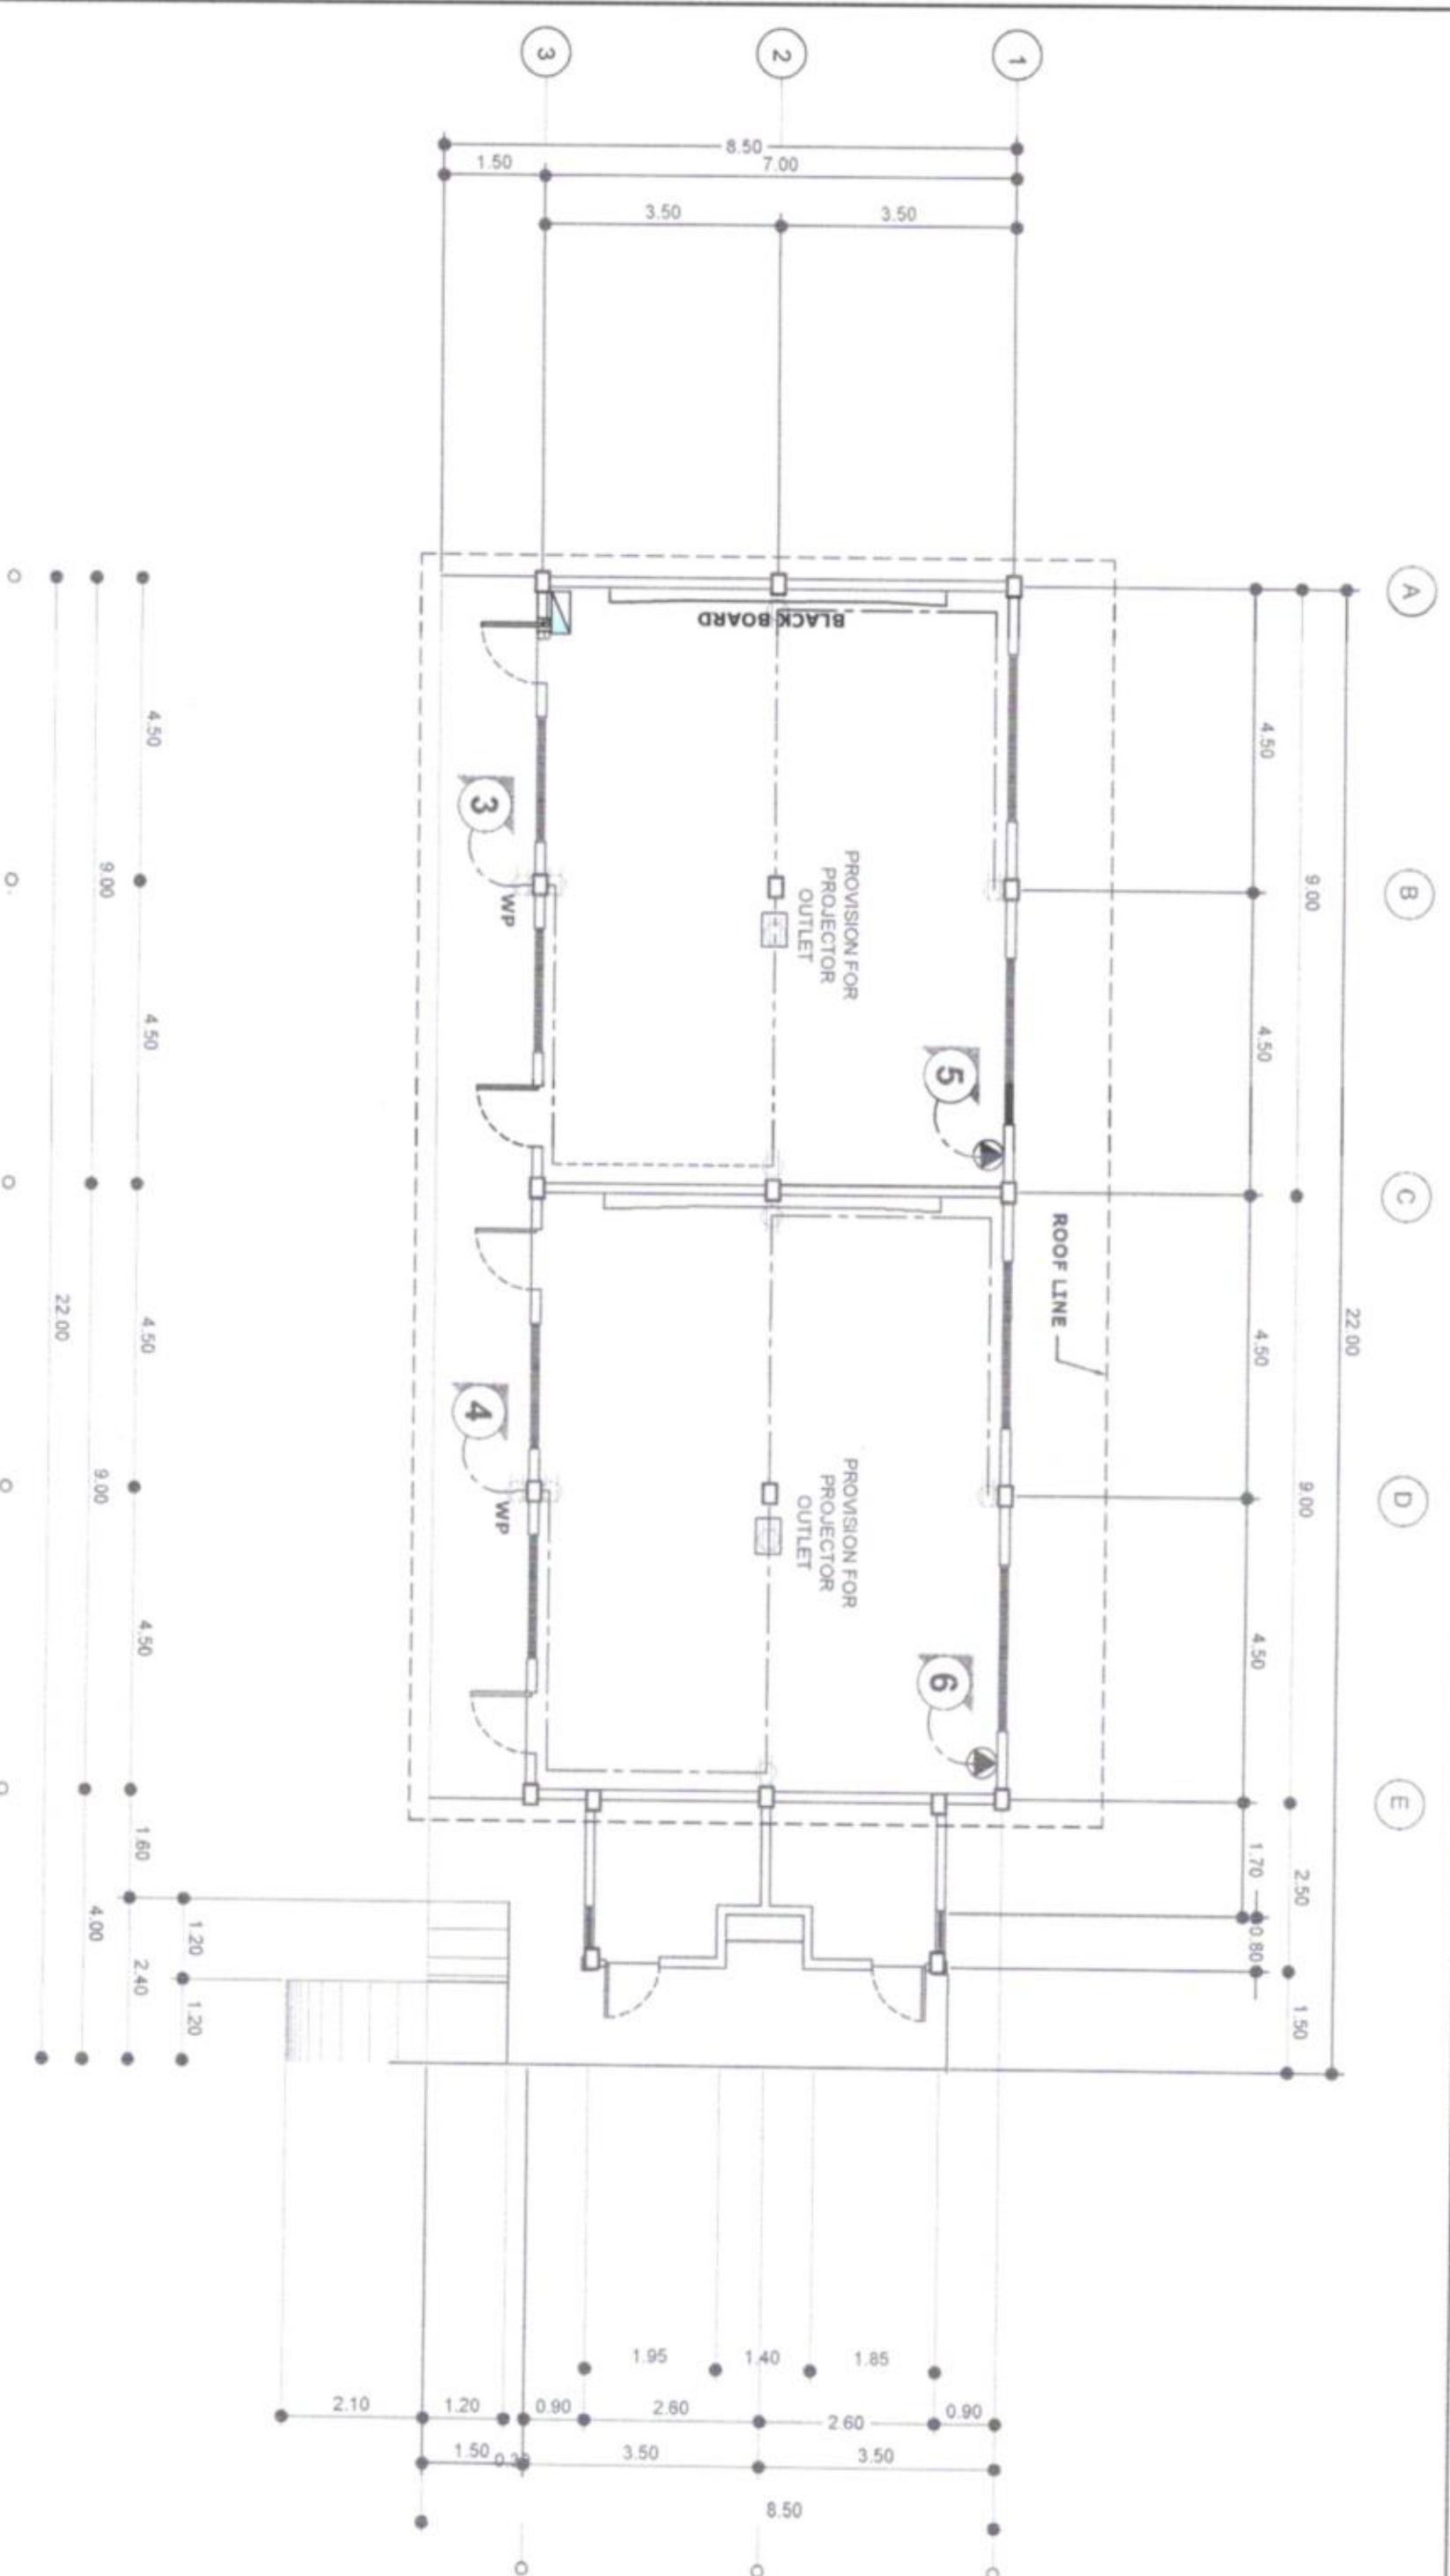

CONVENIENCE OUTLET LAY-OUT PLAN
SCALE: 1:100
MTS

		PROJECT TITLE & LOCATION: CONSTRUCTION OF TWO CLASSROOM (7x9m) BLDG. WITH ATTACHED TOILET		PREPARED BY: HELEN JEAN T. LINGAS ELEC. ENGINEER (I.O.)		CHECKED BY: EDUARDO S. RAMISURA, JR. ELEC. ENGINEER (I)		CONFIRMED BY: GENIALE B. MARFIL, UAP ARCHT. CT. B. Building Section CHM		CONFIRMED BY: PRINCIPAL		SUBMITTED BY: FREDERICK D. SORIANO, MPA HEAD, Planning, Prog. & Design Division		RECOMMENDING APPROVAL: MARILITO S. SANCHEZ PROVINCIAL ENGINEER		APPROVED: REYNALDO S. TAMAYO, JR. PROVINCIAL GOVERNOR		SHEET NO: E-2 1920	
--	--	---	--	--	--	--	--	---	--	-----------------------------------	--	--	--	---	--	--	--	---------------------------------	--

LEGEND



PB PULL BOX

SB SQUARE BOX

JB JUNCTION BOX

UB UTILITY BOX

— POLYVINYL CHLORIDE CONDUIT (PVC) / FLEXIBLE HOSE

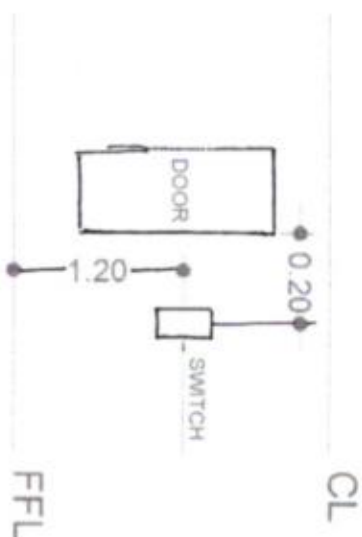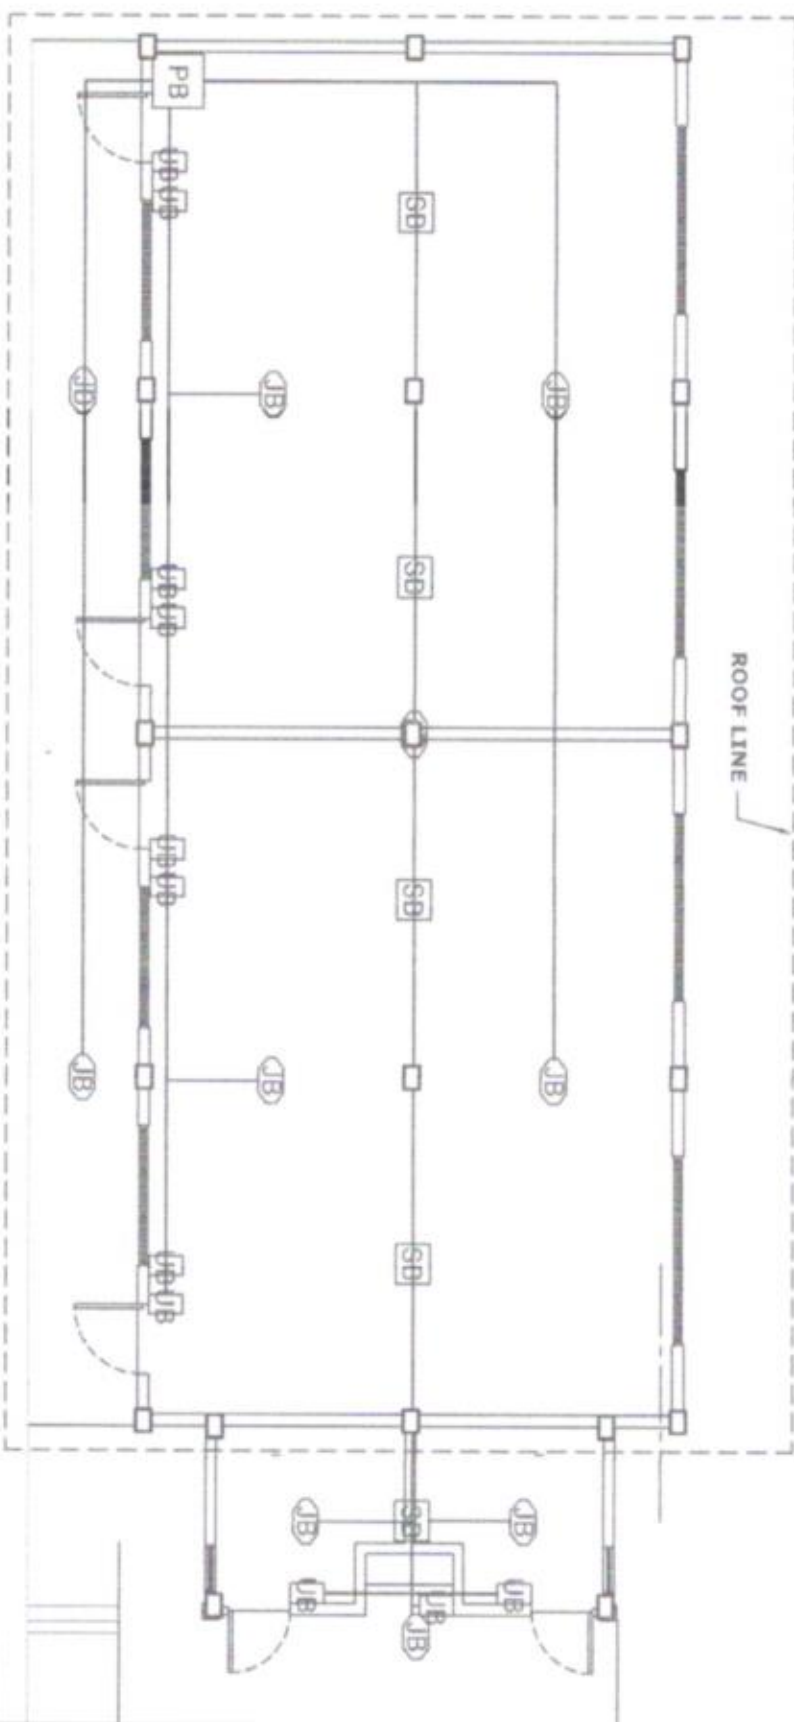

PROPOSED CONDUIT LAYOUT (LIGHTING)
SCALE: 1:100 MTS

FIXTURE LOCATION DETAIL (SWITCHES)

OFFICE OF THE PROVINCIAL ENGINEER PLANNING, PROGRAMMING & BUDGETING DIVISION NORONADA, CITY	PROJECT TITLE & LOCATION: CONSTRUCTION OF TWO CLASSROOM (7X9m) BLDG. WITH ATTACHED TOILET	PREPARED BY: HELEN/GEAN T. LINGAS ELECTRICAL ENGINEER (I/O)	CHECKED BY: EDUARDO S. CAMPOS, JR. ELECTRICAL ENGINEER (I)	DESIGNED BY: GLENDALE B. MARIL, UAP ARCHITECT (Bldg. Section Chief)	CONFORMED BY:	SUBMITTED BY: FREDERICO D. SORIANO, MPA HEAD, Planning, Design & Drawing Division	RECOMMENDING APPROVAL: MARIL D. SORIANO PROVINCIAL ENGINEER	APPROVED: REYNALDO S. TAMAYO, JR. PROVINCIAL GOVERNOR	SHEET NO: E-3 2020
--	--	--	---	--	----------------------	--	--	--	-----------------------------------

LEGEND


PB PULL BOX

SB SQUARE BOX

JB JUNCTION BOX


UB UTILITY BOX

POLYVINYL CHLORIDE CONDUIT
(PVC) / FLEXIBLE HOSE

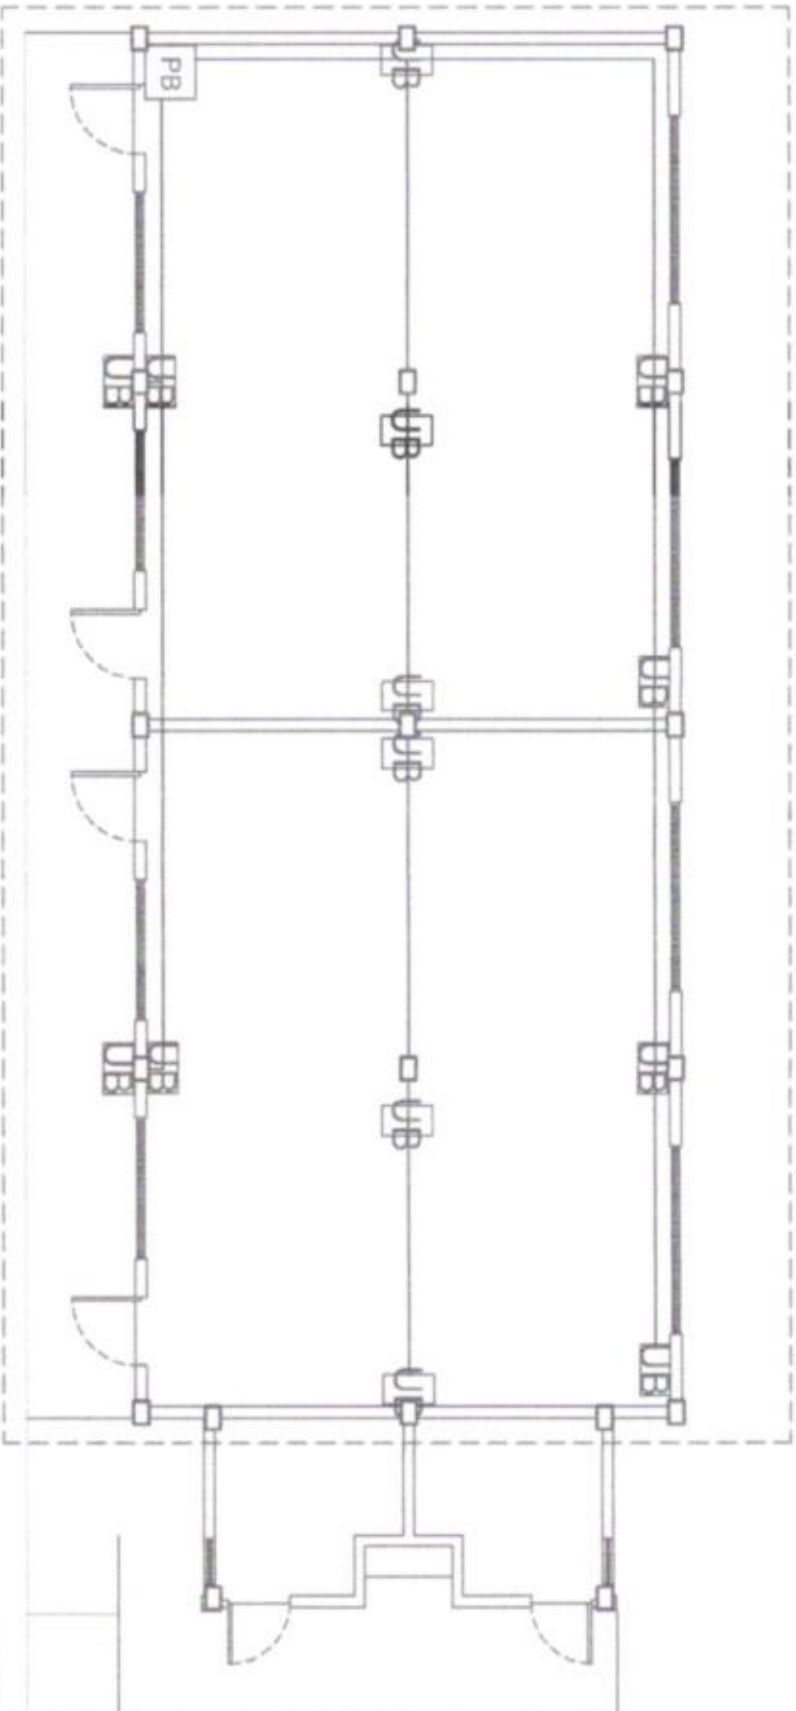

CL

FFL

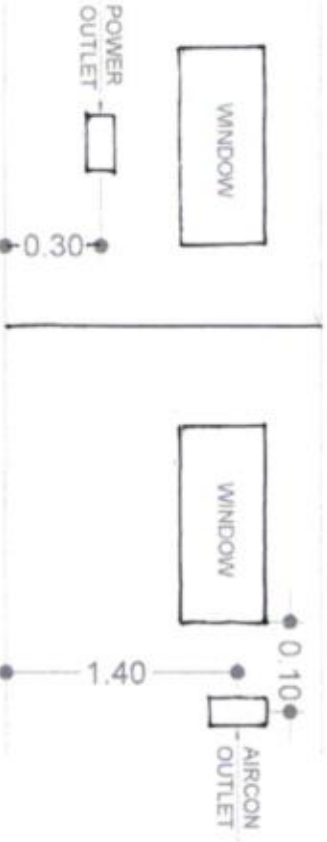

E4 SCALE: 1:100 MTS
PROPOSED CONDUIT LAYOUT (POWER)

FIXTURE LOCATION DETAIL (OUTLETS)

	PROJECT TITLE & LOCATION: CONSTRUCTION OF TWO CLASSROOM (7x9m) BLDG. WITH ATTACHED TOILET		PREPARED BY: HELEN JEAN T. LINGAS ELEC. ENGINEER (UO)		CHECKED BY: EDUARDO S. CAMSURA, JR. ELEC. ENGINEER (UO)		CONFIRMED BY: GLENDAL B. MARFIL, UAP ARCHITECT - Building Division Chief		SUBMITTED BY: FREDERICK D. SORIANO, MPA HEAD Planning, Programming, and Designing Division		RECOMMENDING APPROVAL / APPROVED: MARILLO S. SORIANO PROVINCIAL ENGINEER		SHEET NO. E 4 21/20	
	OFFICE OF THE PROVINCIAL ENGINEER PLANNING, PROGRAMMING, AND REPORTING BRANCH MORONG ADL CITY		HELEN JEAN T. LINGAS ELEC. ENGINEER (UO)		EDUARDO S. CAMSURA, JR. ELEC. ENGINEER (UO)		GLENDAL B. MARFIL, UAP ARCHITECT - Building Division Chief		FREDERICK D. SORIANO, MPA HEAD Planning, Programming, and Designing Division		MARILLO S. SORIANO PROVINCIAL ENGINEER		REYNALDO S. TAMAYO, JR. PROVINCIAL GOVERNOR	

NOTES & SPECIFICATIONS

- ALL ELECTRICAL WORKS SHALL COMPLY IN ACCORDANCE WITH THESE PLANS AND SPECIFICATIONS. THE APPLICABLE PROVISIONS OF THE LATEST EDITION OF THE PHILIPPINE ELECTRICAL CODE (PEC), THE RULES AND REGULATION OF THE LOCAL ENFORCING AUTHORITY AND THE REQUIREMENTS OF THE LOCAL POWER COMPANY SHALL BE SUPERVISED BY A REGISTERED ELECTRICAL ENGINEER.
- THE ELECTRICAL SERVICE POWER IS 1-PHASE, 2-WIRE, 230V AC, 60Hz.
- WIRING METHOD SHALL BE AS FOLLOWS:
 - FEEDERS AND RISER
 - LIGHTING, POWER RECEPTACLE
 - POLYVINYL CHLORIDE CONDUIT
 - BRANCH CKT. & AUXILIARY
 - SCH. 40, SERIES 1000
- ALL WIRES SHALL BE COPPER AND THERMOPLASTIC INSULATED TYPE "THW" UNLESS OTHERWISE INDICATED IN THE PLAN. THE MINIMUM SIZE OF THE WIRE FOR POWER AND LIGHTING CIRCUIT HOMERUN SHALL BE 2.0mm AND INSULATED FOR 600 VOLTS. SMALLEST RACEWAY SHALL BE 20mm TRADE NOMINAL SIZE.
- ALL OUTLET BOXES SHALL BE POLYVINYL CHLORIDE CONDUIT.
- ALL MATERIAL TO BE USED SHALL BE BRAND NEW AND OF APPROVED TYPE IN PARTICULAR SPECIFIED LOCATION AND AS PER PURPOSE OF USAGE.
- MOUNTING HEIGHT OF WIRING DEVICES SHALL BE AS FOLLOWS:
 - LIGHT SWITCH
 - CONVENIENCE OUTLET
 - PANELBOARD
- ALL ELECTRICAL ROUGHING INSCONDUITS MUST BE CHECKED BY THE DESIGNER AND THE PROJECT ENGINEER PRIOR TO PULLING OF WIRES.

LEGEND


- LED RECESSED DOWNLIGHT
- ULTRA-THIN WIDE BEAM ANGLE
- S-7.5" LED 257080DL, 8W MINIMUM
- 520LM
- 18 ALUMINUM LOUVER WITH
- EXTREME ELECTRONIC BALLAST
- WITH TUBE 7'X24" (ST), 1X18W
- CEILING FAN
- WALL FAN
- ONE GANG DEVICE SWITCH
- TWO GANG DEVICE SWITCH
- THREE GANG DEVICE SWITCH
- FAN CONTROL SWITCH
- PANELBOARD
- 2-GANG CONVENIENCE
- FLOOR OUTLET
- WEATHERPROOF DUPLEX
- CONVENIENCE OUTLET
- DUPLEX CONVENIENCE OUTLET,
- GROUNDING TYPE 10 AMPS, 220
- VOLT WITH MODERN COVER
- AIRCON OUTLET
- CIRCUIT BREAKER, RATING IS
- INDICATED

LOAD SCHEDULE


CIRCUIT NO.	DESCRIPTION	QTY	VA	V	A	PROTECTION	SIZE OF WIRE	CONDUIT
1	LIGHTING OUTLET	8	800	230	3.48	15 AT	2.0mm ² THHN	20 mm Ø UPVC
2	LIGHTING OUTLET	11	1100	230	4.78	15 AT	2.0mm ² THHN	20 mm Ø UPVC
3	POWER OUTLET	6	1080	230	4.70	20 AT	3.5mm ² THHN	20 mm Ø UPVC
4	POWER OUTLET	6	1080	230	4.70	20 AT	3.5mm ² THHN	20 mm Ø UPVC
5	AIRCON OUTLET	1	1380	230	12.0	30 AT	5.5mm ² THHN	20 mm Ø UPVC
6	AIRCON OUTLET	1	1380	230	12.0	30 AT	5.5mm ² THHN	20 mm Ø UPVC
7	SPARE							
8	SPARE							

It = 41.66 A FEEDER: 2-14mm² THHN IN 32mm Ø RSC PIPE MAIN CB: 60AMP CB

ONE LINE DIAGRAM

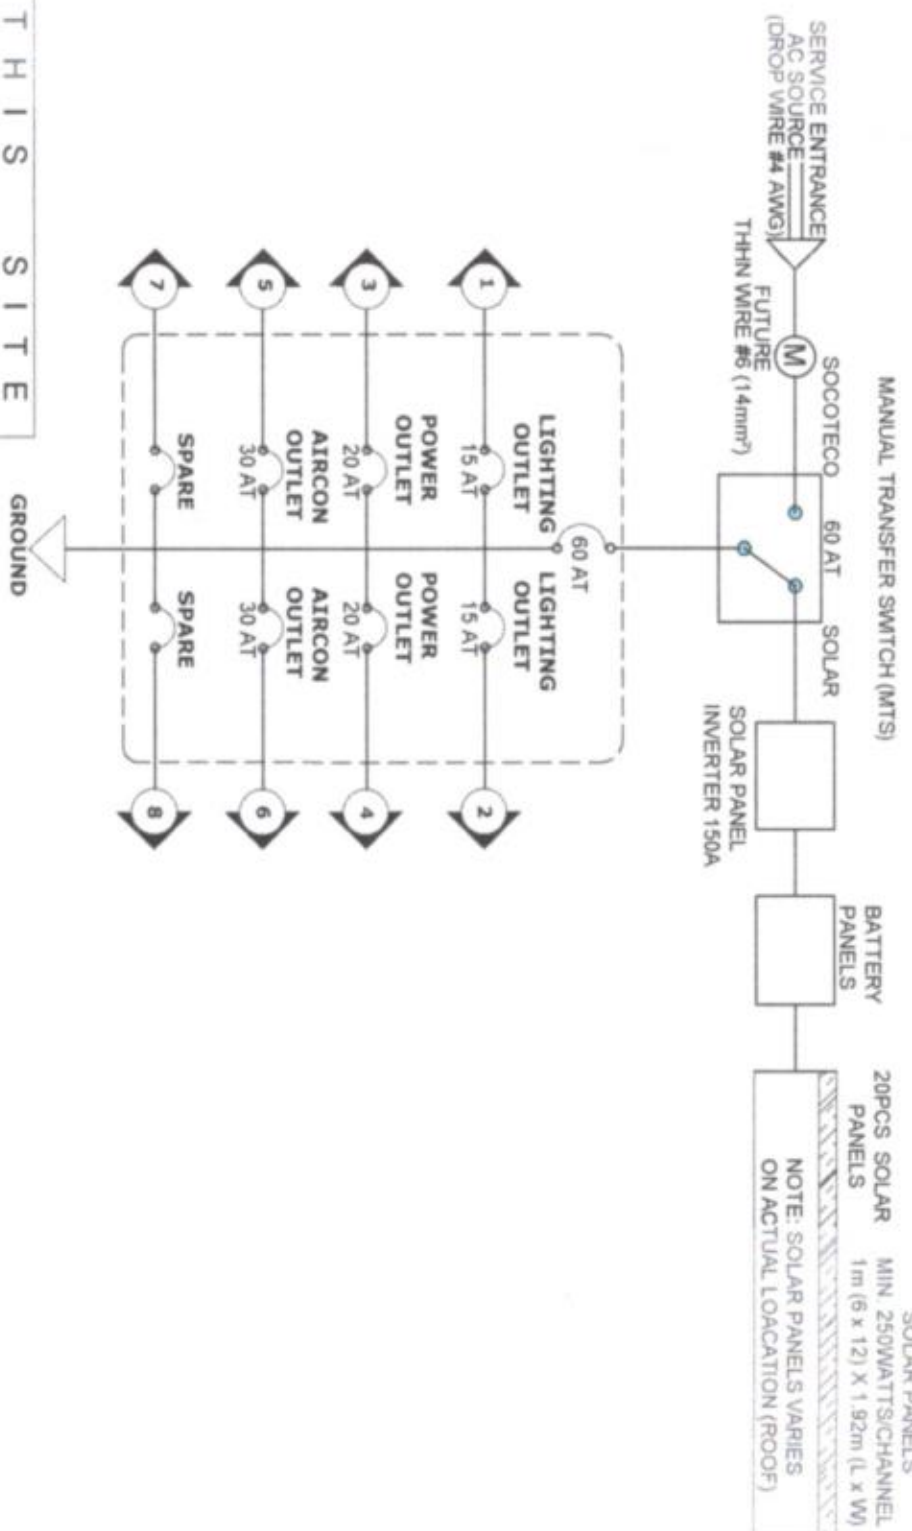

VICINITY MAP

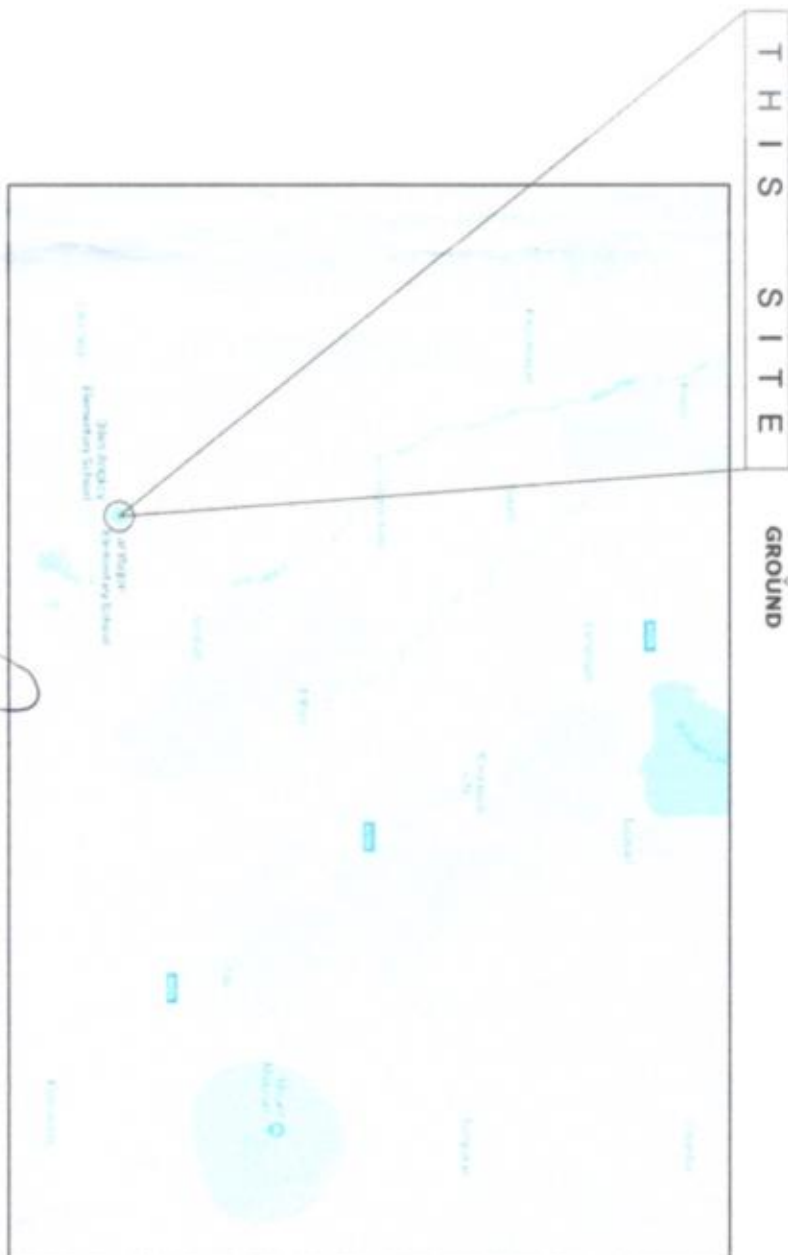

REPUBLIC OF THE PHILIPPINES OFFICE OF THE PROVINCIAL ENGINEER PLANNING, PROGRAMMING & DESIGN DIVISION MORONG, CITY	PROJECT TITLE & LOCATION: CLASSROOM (7X8m) BLDG. WITH ATTACHED TOILET	PREPARED BY: HELEN JEAN YUNGAS ELECT. ENGINEER (U.O.)	CHECKED BY: EDUARDO S. CAMISURA, JR. ELECT. ENGINEER	CONFORMED BY: GLENDALE B. MARFIL, UAP ARCHITECT III, Building Section Chief	CONFORMED BY:	SUBMITTED BY: FREDERICK D. SORIANO, MPA HEAD, Planning, Program & Design Division	RECOMMENDING APPROVAL: MARILLO S. PEROCHO PROVINCIAL ENGINEER	APPROVED: REYNALDO S. TAMAYO, JR. PROVINCIAL GOVERNOR	SHEET NO. E 5 2220
---	---	---	--	---	---------------	---	---	---	--------------------------